

OWNER  
**MILL TO PARTNER**  
 190 E PENNSYLVANIA  
 BUILDING 400 SUITE  
 DOWNTOWN, PA

STRUCTURE

M.E.P.

CONSULTA




ARCHITECT  
**ARCHITECT**  
**CON**  
**LLP**  
 1000 N. MARKET STREET  
 PHILADELPHIA, PA 19107  
 TEL: 215.566.1000  
 FAX: 215.566.1001  
 WWW.ARCHITECTCONLLP.COM

PROJECT  
**ELWYN**  
**READING**  
**CAMPUS**  
**BERKS COUNTY**

NO.	DATE	REVISION
1	11/11/15	ISSUE FOR PERMIT

FLOOR PL

700 LANCASTER  
 READING  
 BERKS COUNTY

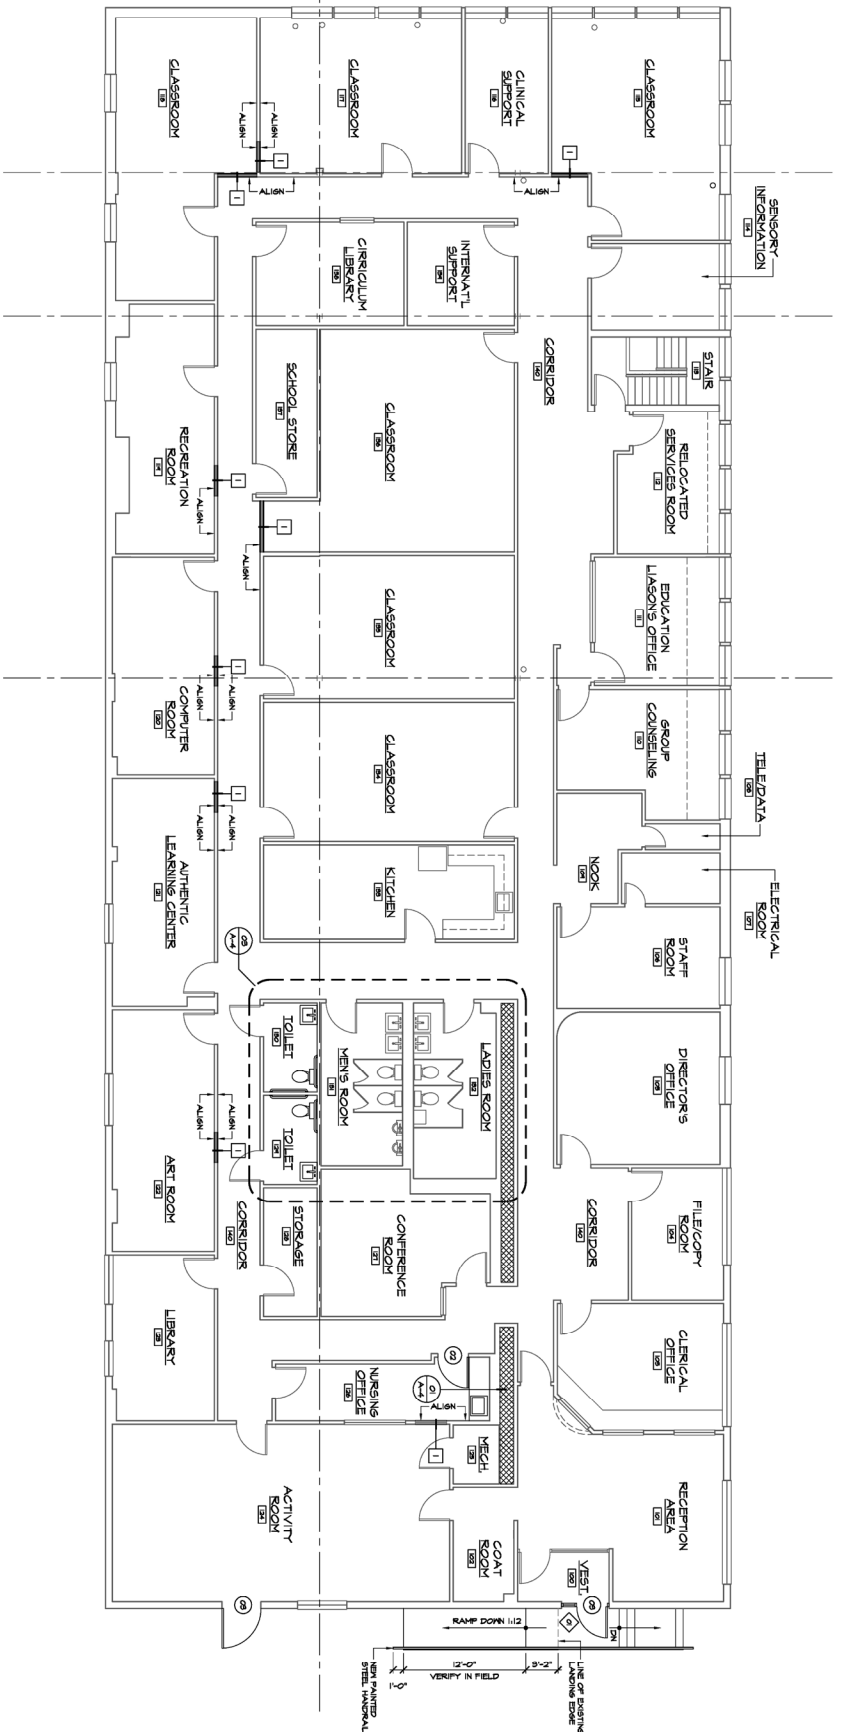

**01 FLOOR PLAN**  
 SCALE: 1/4"=1'-0"  
 PROJECT NORTH

THIS BUILDING TO BE FULLY FINISHED BY AN AUTOMATIC SPRINKLER SYSTEM TO MEET ALL APPLICABLE NATIONAL, STATE AND LOCAL CODES.