


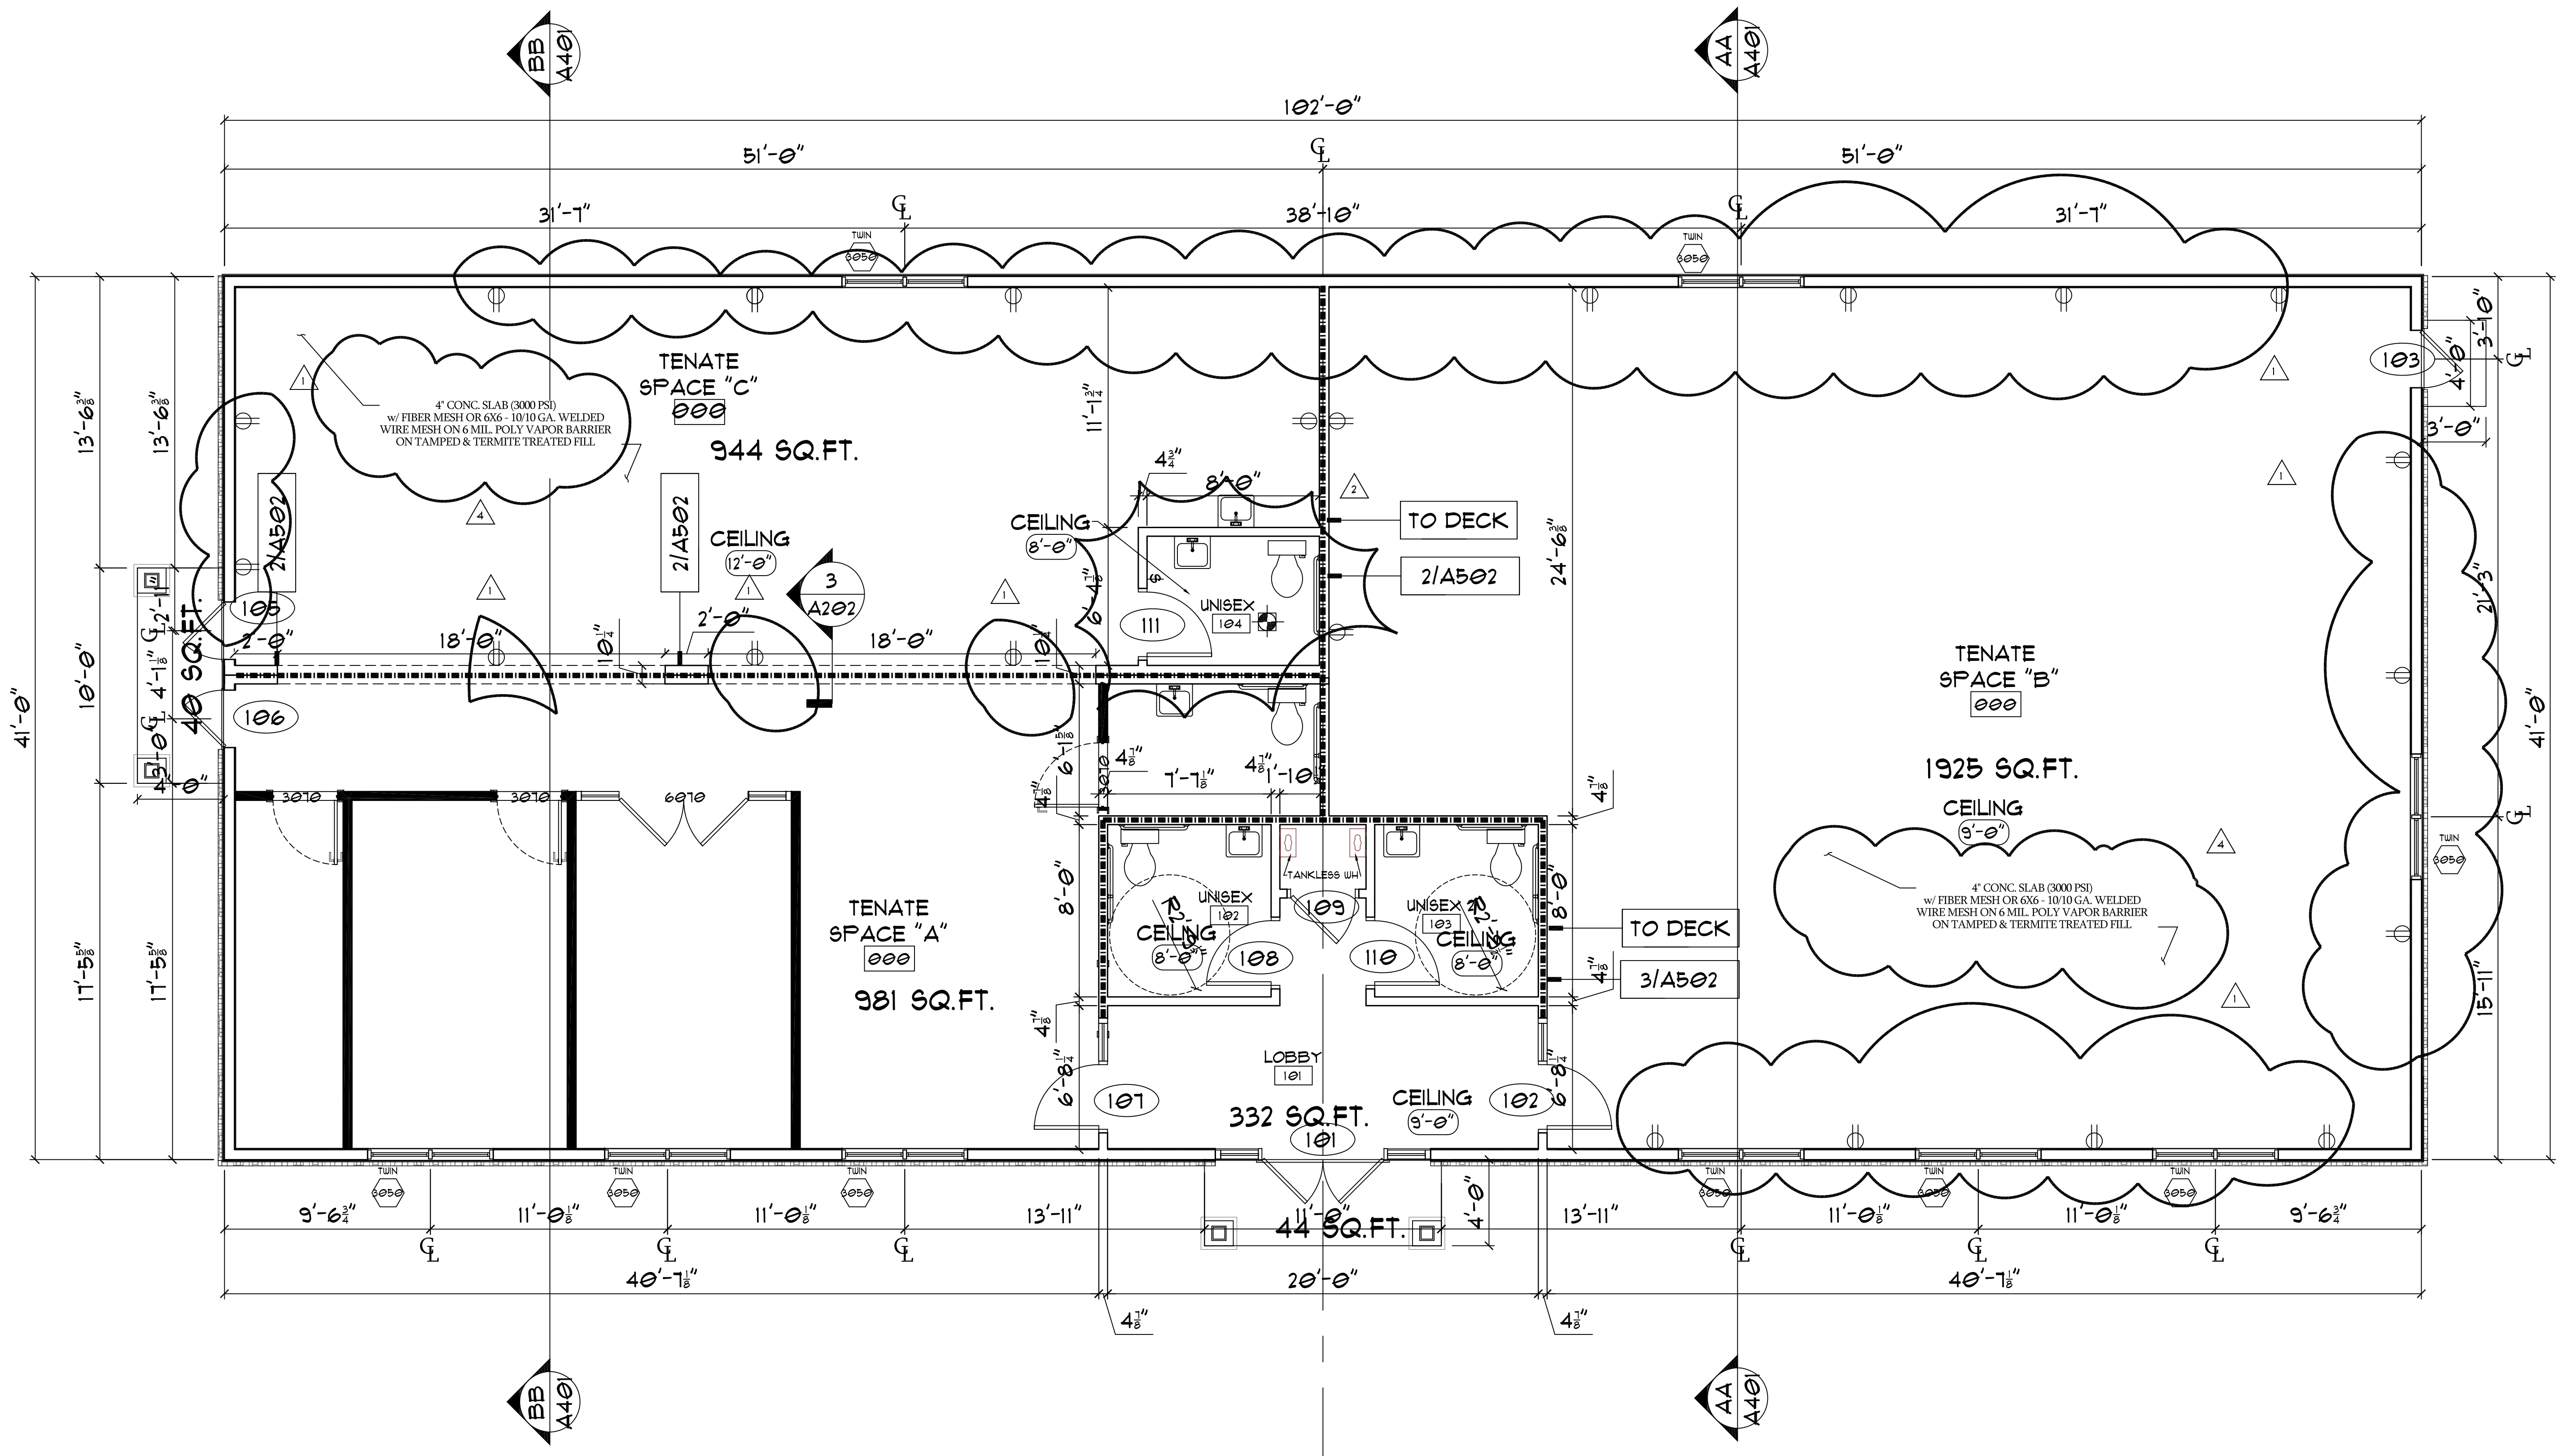

FLOOR PLAN
1/4"=1'-0"

- 1. ADDED OUTLETS TO PERIMETER WALLS (PER CODE)
- 2. ADDED (2) SINGLE CLOSET RESTROOMS
- 3. ADDED DOORS III, TO DOOR SCHEDULE SH. A-501
- 4. ADDED FINISH FLOOR NOTE.

ELECTRICAL LEGEND	
	FAN/LIGHT COMBO
	OUTLET
	LIGHT SWITCH

DISCLAIMER AND INFORMATION: The Architect's role in the design of this project is to provide professional services in accordance with the standards of the architectural profession. The Architect is not responsible for the design or performance of any other trades or materials used in the construction of the project. The Architect is not responsible for the accuracy of any information provided by others. The Architect is not responsible for the construction of the project. The Architect is not responsible for the safety of the project. The Architect is not responsible for the environmental impact of the project. The Architect is not responsible for the social impact of the project. The Architect is not responsible for the economic impact of the project. The Architect is not responsible for the cultural impact of the project. The Architect is not responsible for the historical impact of the project. The Architect is not responsible for the archaeological impact of the project. The Architect is not responsible for the paleontological impact of the project. The Architect is not responsible for the biological impact of the project. The Architect is not responsible for the geological impact of the project. The Architect is not responsible for the hydrological impact of the project. The Architect is not responsible for the atmospheric impact of the project. The Architect is not responsible for the climate impact of the project. The Architect is not responsible for the land use impact of the project. The Architect is not responsible for the transportation impact of the project. The Architect is not responsible for the infrastructure impact of the project. The Architect is not responsible for the public works impact of the project. The Architect is not responsible for the utilities impact of the project. The Architect is not responsible for the telecommunications impact of the project. The Architect is not responsible for the energy impact of the project. The Architect is not responsible for the water impact of the project. The Architect is not responsible for the waste impact of the project. The Architect is not responsible for the recycling impact of the project. The Architect is not responsible for the sustainability impact of the project. The Architect is not responsible for the green building impact of the project. The Architect is not responsible for the LEED impact of the project. The Architect is not responsible for the WELL impact of the project. The Architect is not responsible for the Fitwel impact of the project. The Architect is not responsible for the GreenSource impact of the project. The Architect is not responsible for the GreenWash impact of the project. The Architect is not responsible for the GreenCheck impact of the project. The Architect is not responsible for the GreenSource impact of the project. The Architect is not responsible for the GreenWash impact of the project. The Architect is not responsible for the GreenCheck impact of the project.

BUILDING #1
CAROLINA FOREST
BUSINESS PARK
SURGEONS DRIVE, CAROLINA FOREST
MYRTLE BEACH, SC 29519

JOB NO:
DRAWN: KJ
CHECKED: AKB
DATE: 12-19-19
REVISIONS:
12-22-20
1-05-22



SHEET NO:
A-101

BALLARD ARCHITECTS
A KENT BALLARD, AIA & ASSOCIATES
A DIVISION OF BALLARD DEVELOPMENT CORPORATION
3726 KINGSLEY DRIVE, MYRTLE BEACH, SOUTH CAROLINA 29588
PH 703 472 1165
EMAIL: AKB@BALLARDARCHITECTS.COM
© Copyright