


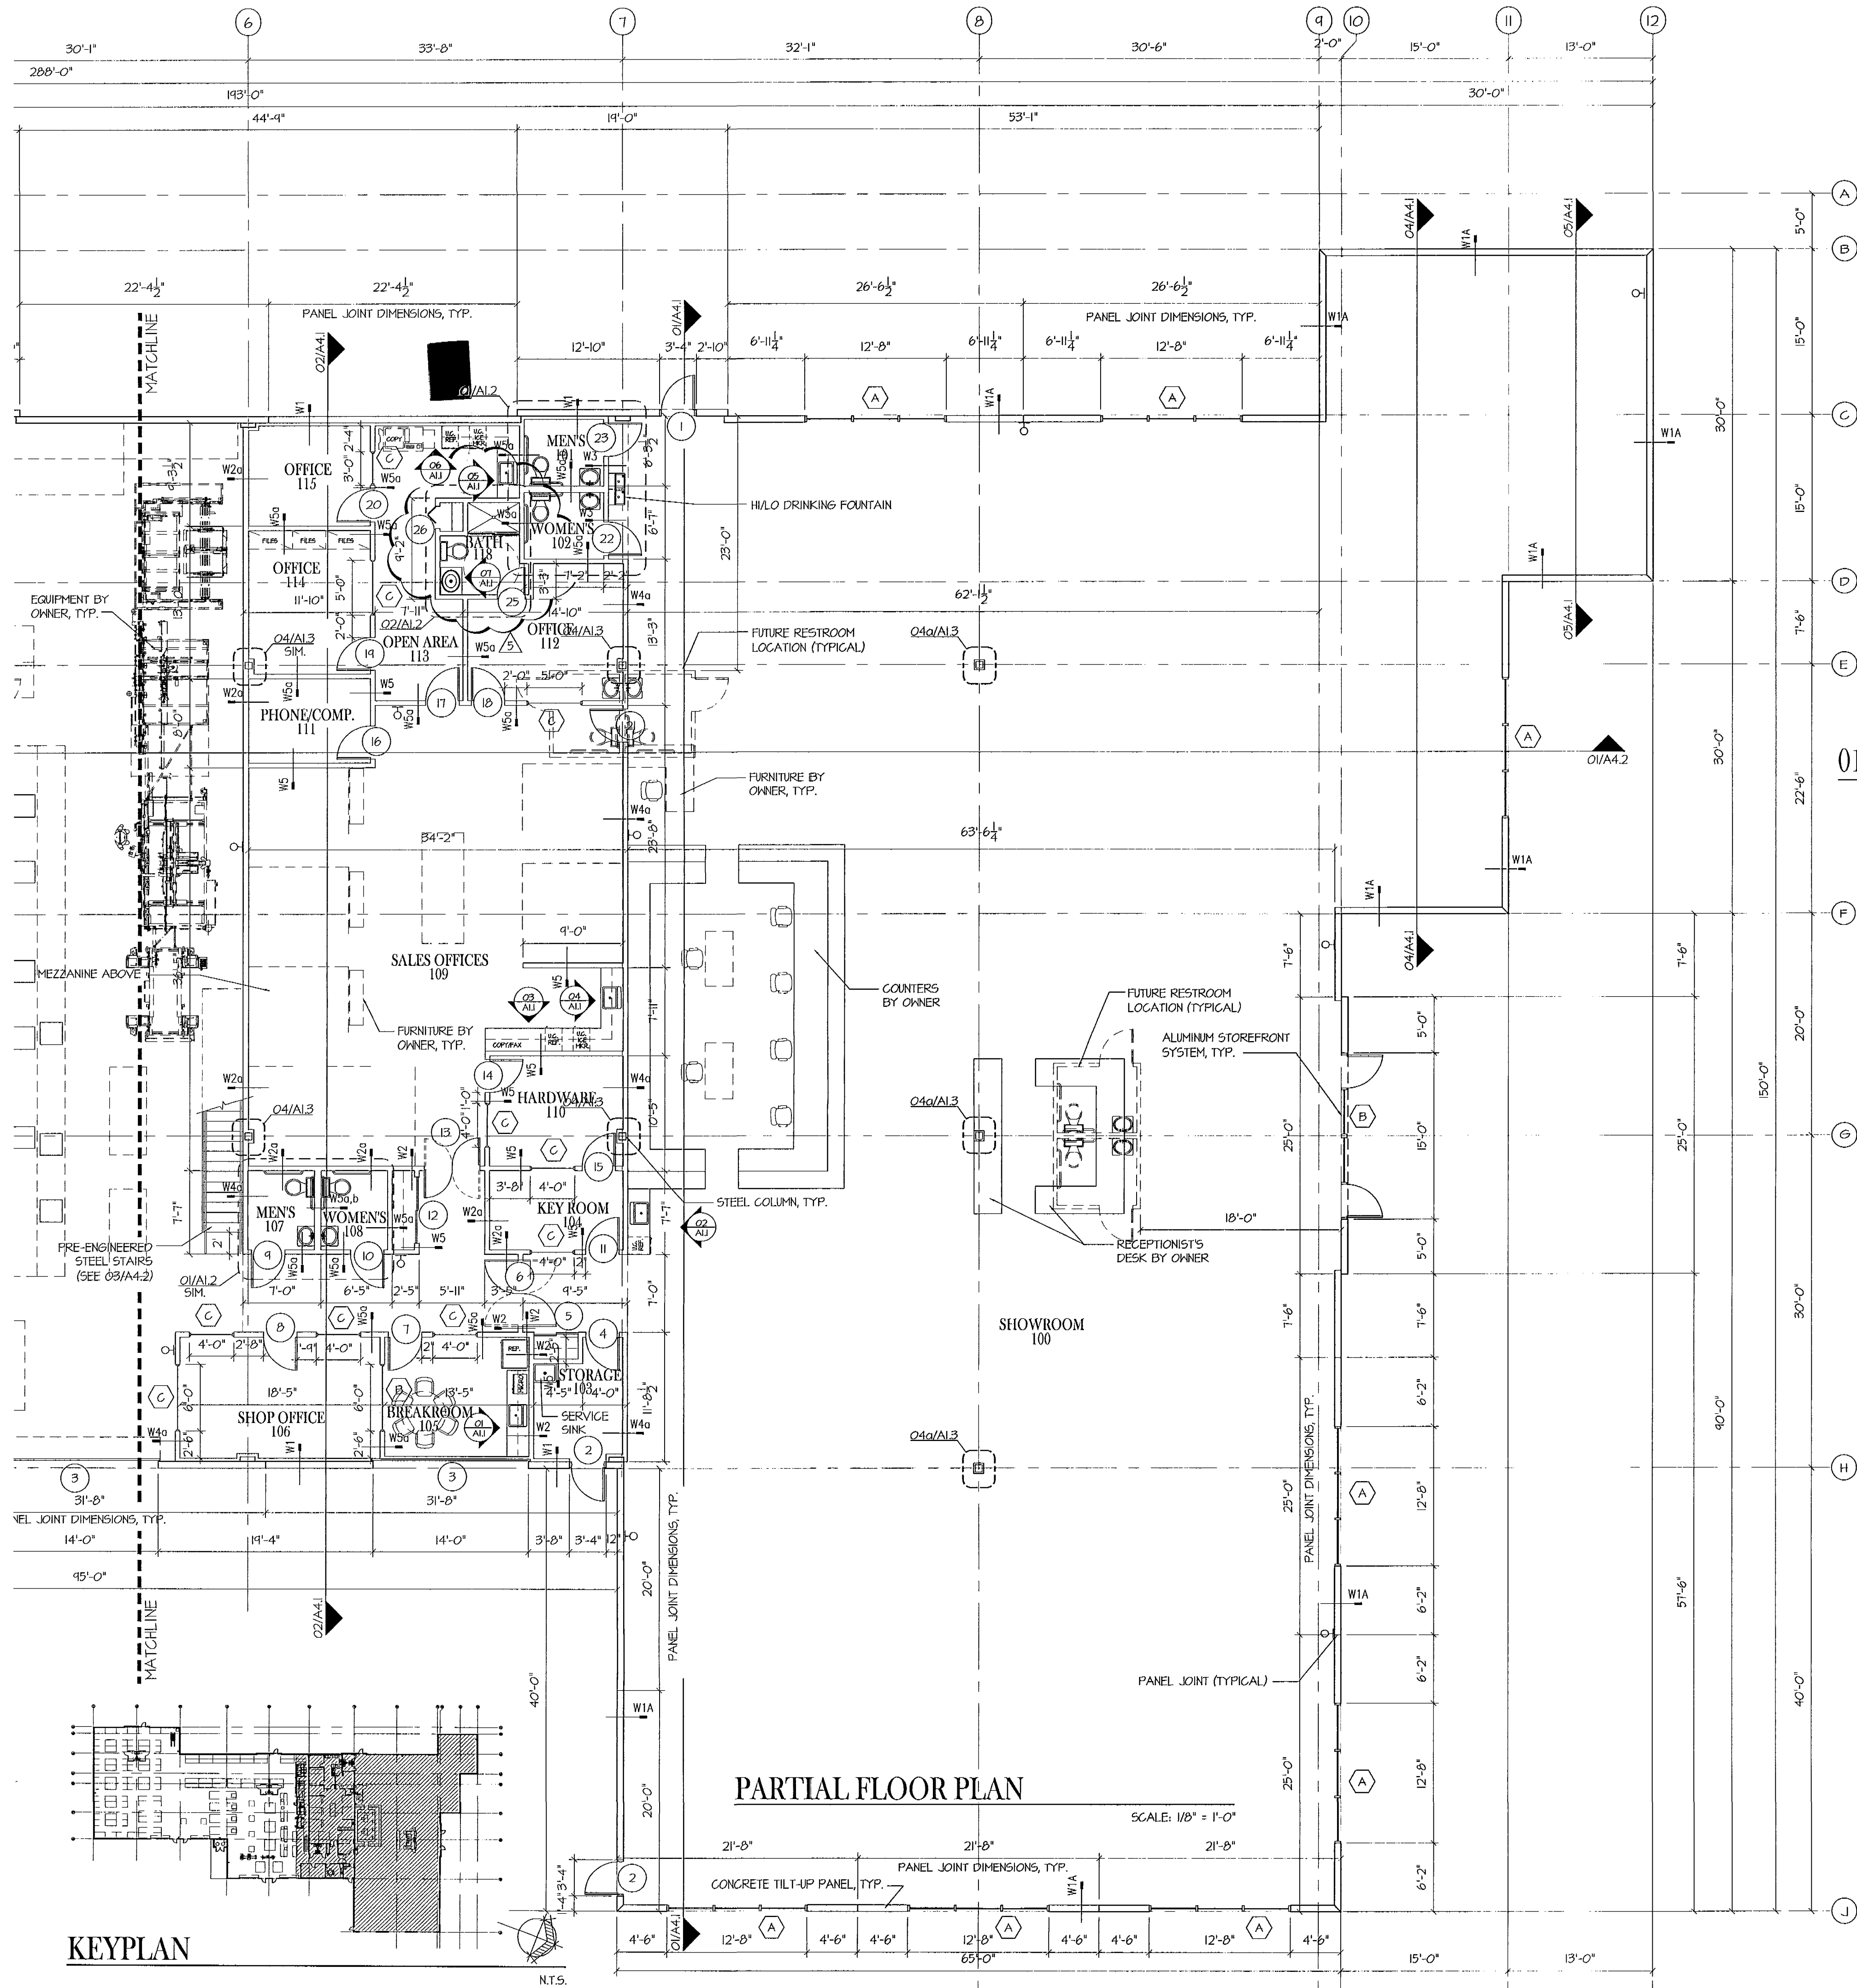

KEYPLAN

PARTIAL FLOOR PLAN

SCALE: 1/8" = 1'-0"

MOUNTING HEIGHT DETAILS

01 ENLARGED RESTROOM PLAN

02 ENLARGED BATHROOM PLAN

RESTROOM ACCESSORIES

- GB1 36" STAINLESS STEEL GRAB BAR
- GB2 42" STAINLESS STEEL GRAB BAR
- MS 18"x30" STEEL MIRROR
- TW SURFACE MOUNTED PAPER TOWEL DISPENSER
- SD WALL MOUNTED LIQUID SOAP DISPENSER
- RH TOILET PAPER DISPENSER
- DF H/L/O DRINKING FOUNTAIN

NOTE: SEE PLUMBING PLANS FOR ADDITIONAL INFORMATION

tercilla **courtemanche** architects


NEW FLEX BUILDING FOR:
SMITH & DeSHIELDS, Inc.
JUPITER PARK OF COMMERCE
LOT 33
JUPITER, FLORIDA

commission	24084
date:	4-22-05
revision	date
no. 1	7/20/05
2	11/21/05
3	2/14/06
4	4/6/06


TOWN OF JUPITER
BUILDING
MAY - 2 2006
REVIEWED FOR
CODE COMPLIANCE

REVISIONS
APR 17 2006
TOWN OF JUPITER
BUILDING DIVISION

drawing
A1.2
copyright 2005

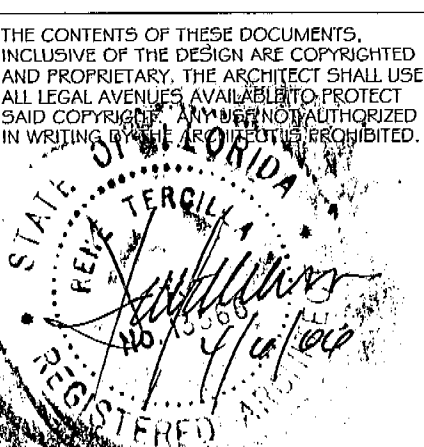

3233 commerce place, suite b
west palm beach, florida 33407
ph: 561.478.4437 fx: 561.478.4102

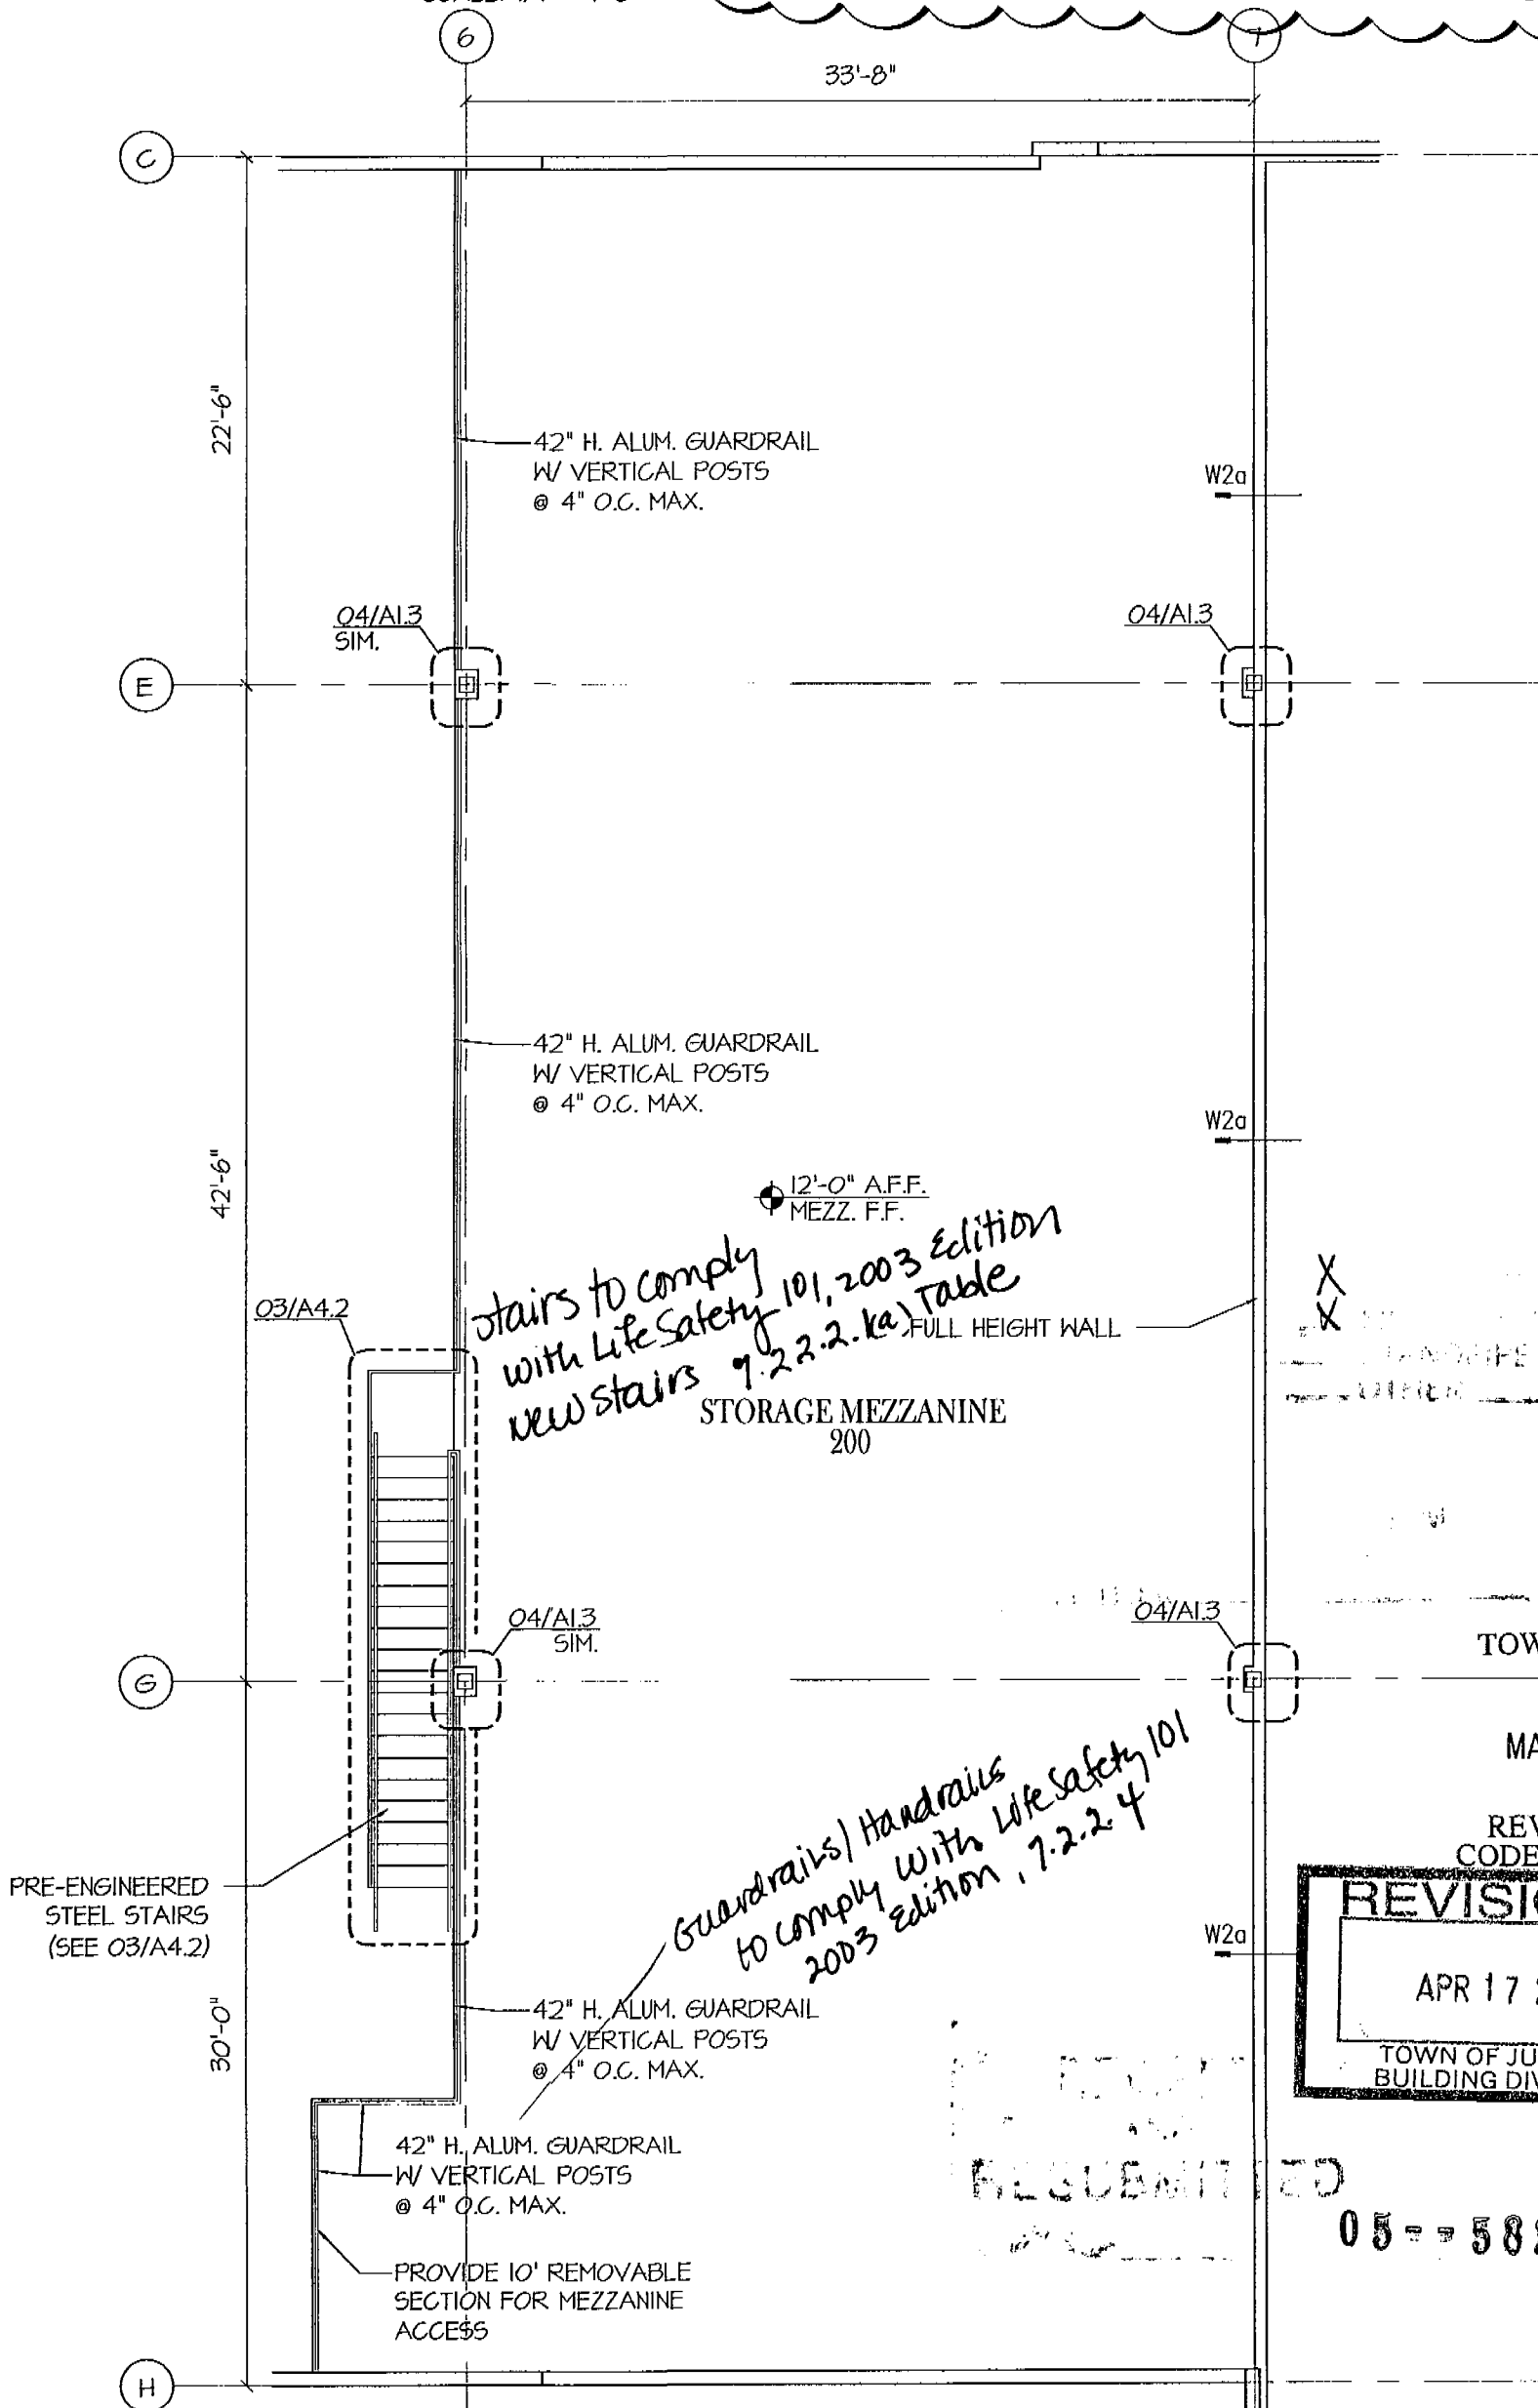

MEZZANINE PLAN

SCALE: 1/8" = 1'-0"