


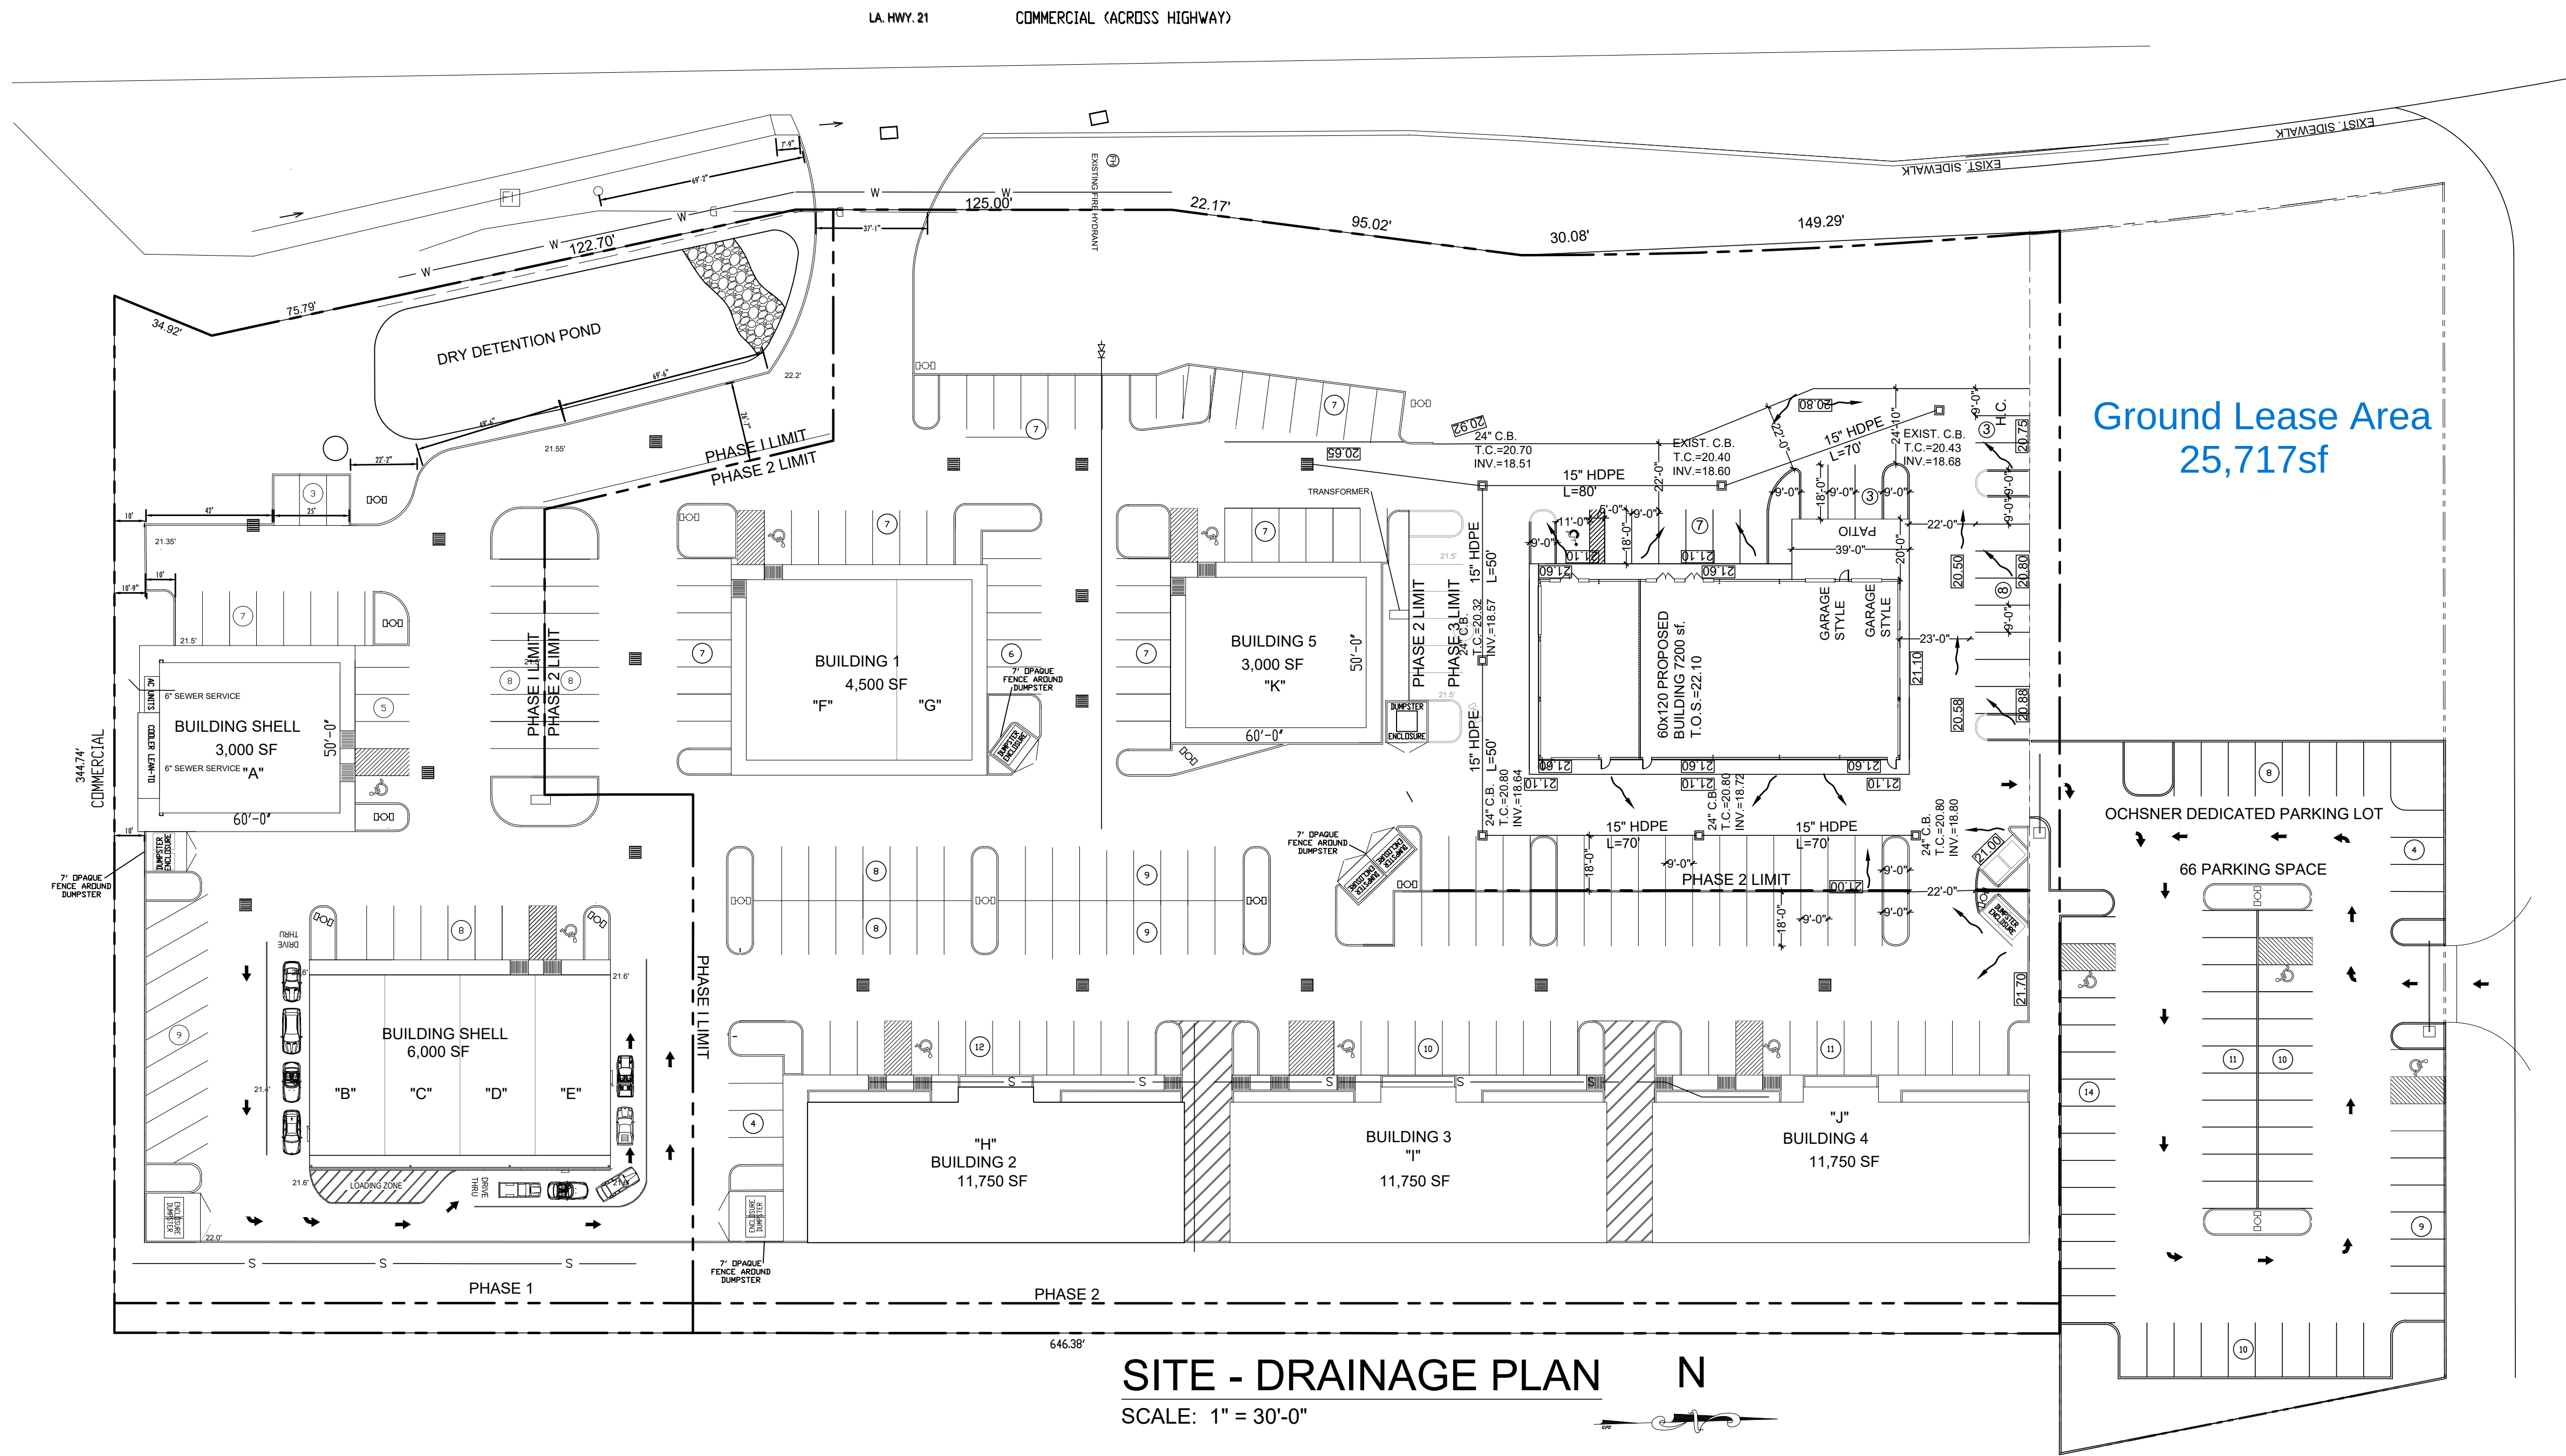

SITE - DRAINAGE PLAN N
SCALE: 1" = 30'-0"

Ground Lease Area
25,717sf

ARROW ENGINEERING
& CONSULTING
DARRELL FUSSELL, P.E.
darruss123@gmail.com

PO BOX 881
Madisonville, LA 70447
Phone: 985-237-3908

PECK'S HWY 21
COVINGTON, LA 70433

Issue	Description	Date
A	FOR REVIEW	5-07-21