

KAO-HWA LEE
ARCHITECTS P.C.
227 CANTERBURY STREET
SOUTH AMBOY, NJ 08879
908.276.2975

SECH & MINIFICAL
CONSULTANT
THE ASSOCIATES INC.
870 MARKET AVENUE #205
BROOKLYN, NY 11205
T 718.489.8242
info@theassociatesinc.com

STRUCTURAL ENGINEER

MEP ENGINEER

OWNER
B Construction Group LLC
180 Monticelli Ave. Suite 400A
Brooklyn, NY 11211
T 718.488.8778

No.	Description	Date
1	AS-BUILT	10/1/2024
2	REVISION	10/1/2024
3	REVISION	10/1/2024
4	REVISION	10/1/2024
100	REVISION	10/1/2024

LOCATION
526 BALTIC STREET
BROOKLYN NY

SHEET TITLE
PROPOSED FIRST
FLOOR PLAN

A-101.1

15 OF 49

Drawn by	As of/used
KA	10/1/2024
Checked by	KA
100% JOB NUMBER	491

B00667885-A1

TABLE 403.1 APPROXIMATE NUMBER OF REQUIRED PLUMBING FIXTURES						
NO.	CLASSIFICATION	OCCUPANCY	DESCRIPTION	WATER CLOSETS URINALS	LAVATORIES	DRINKING FOUNTAINS
1	MERCHANDISE	M	RETAIL STORES, SERVICE STATIONS, SHOPS, SALESROOMS, MARKETS AND SHOPPING CENTERS	1 PER 100	1 PER 750	1 PER 1,000

GENERAL PLAN LEGEND

FLOOR DRAIN

WALL TAG

DOOR TAG

WINDOW TAG

GLASS WALL

GLASSING WALL TO REMAIN


GLASS PARTITION

TRIP INTERIOR PARTITION

SECTION TAG

EXTERIOR ELEVATION TAG

EXTERIOR ELEVATION TAG

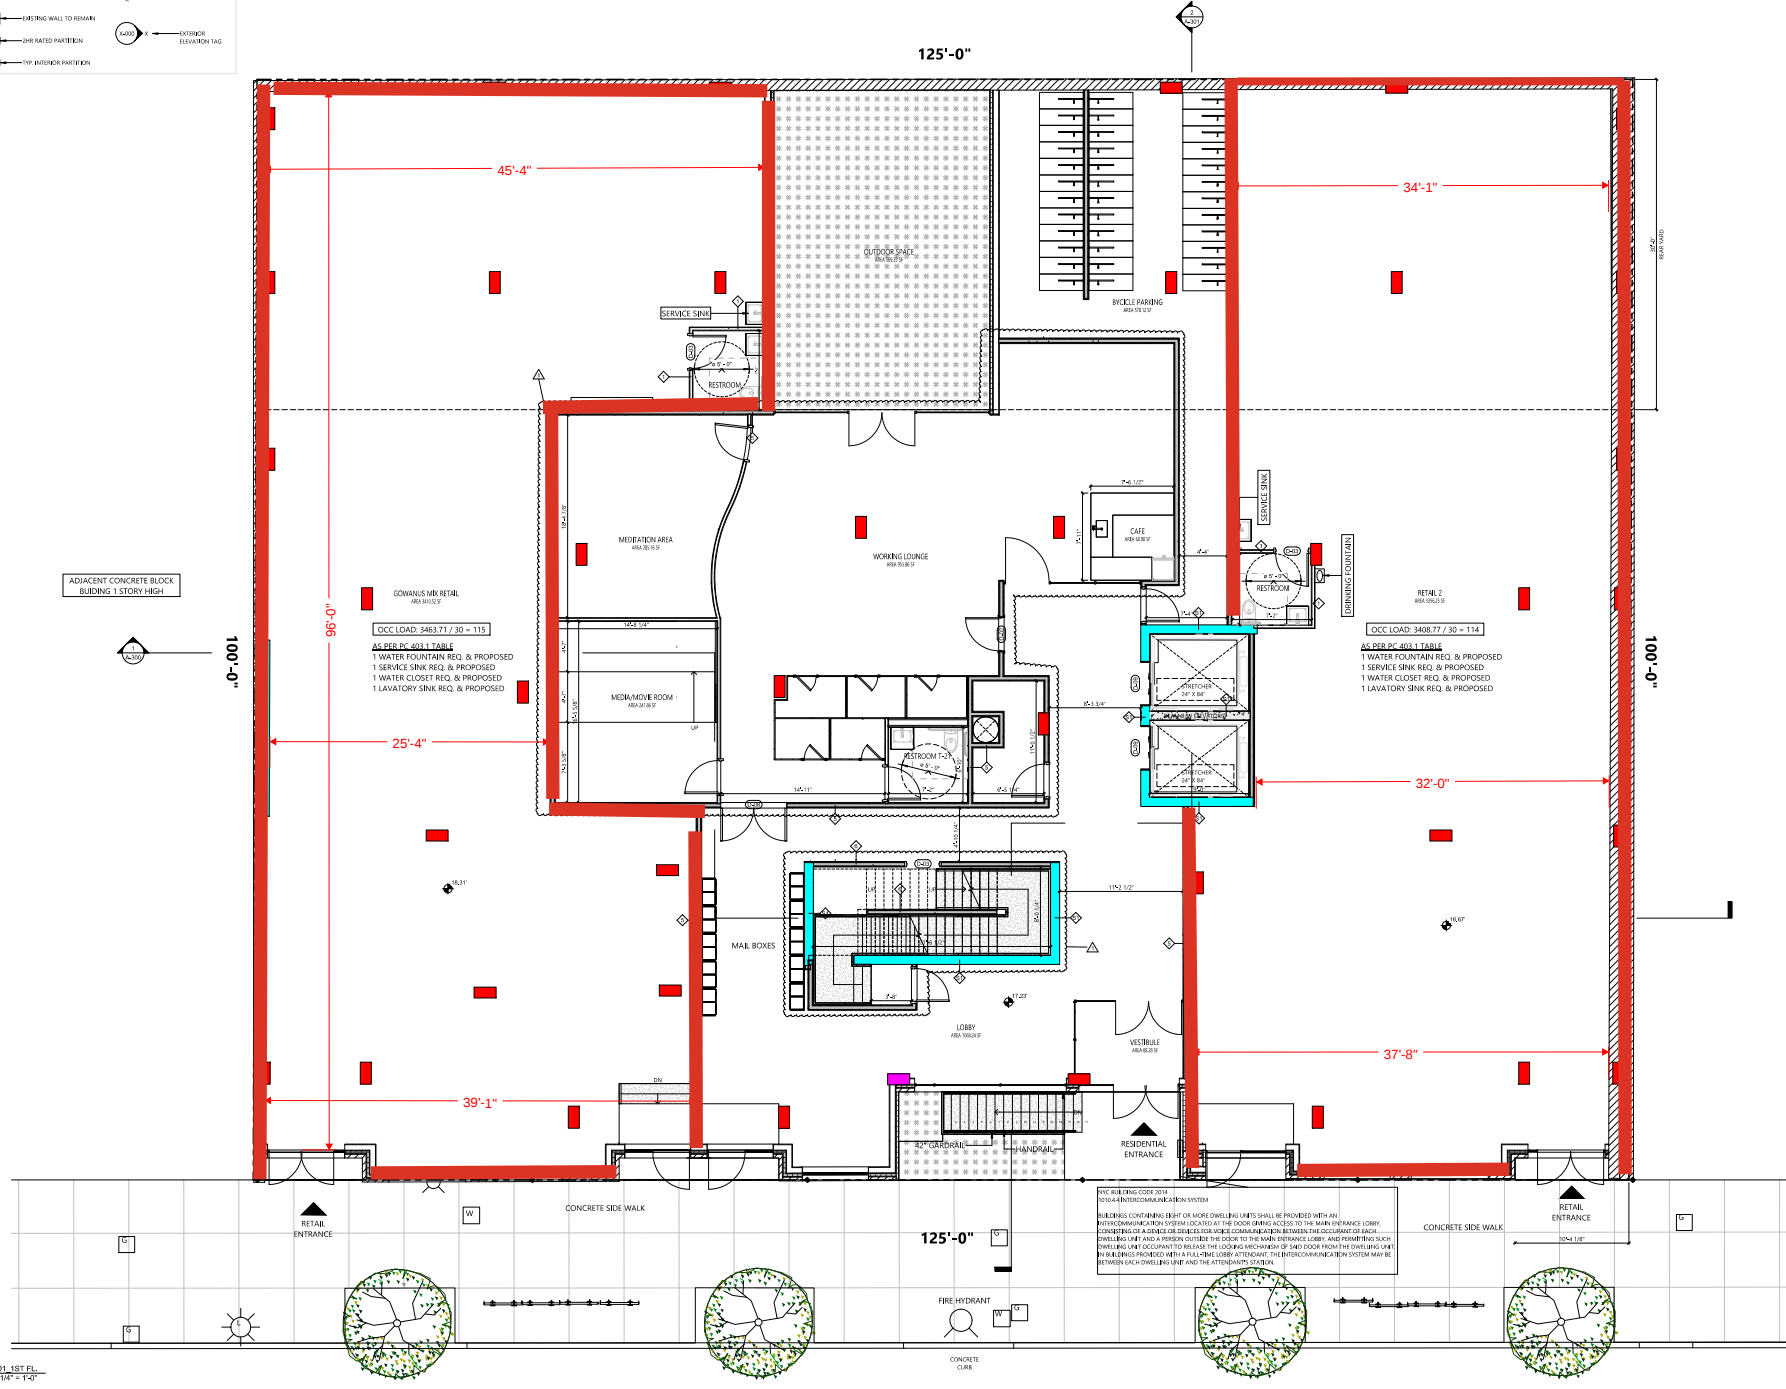

1. 01.101.1
100' = 1" = 10'