

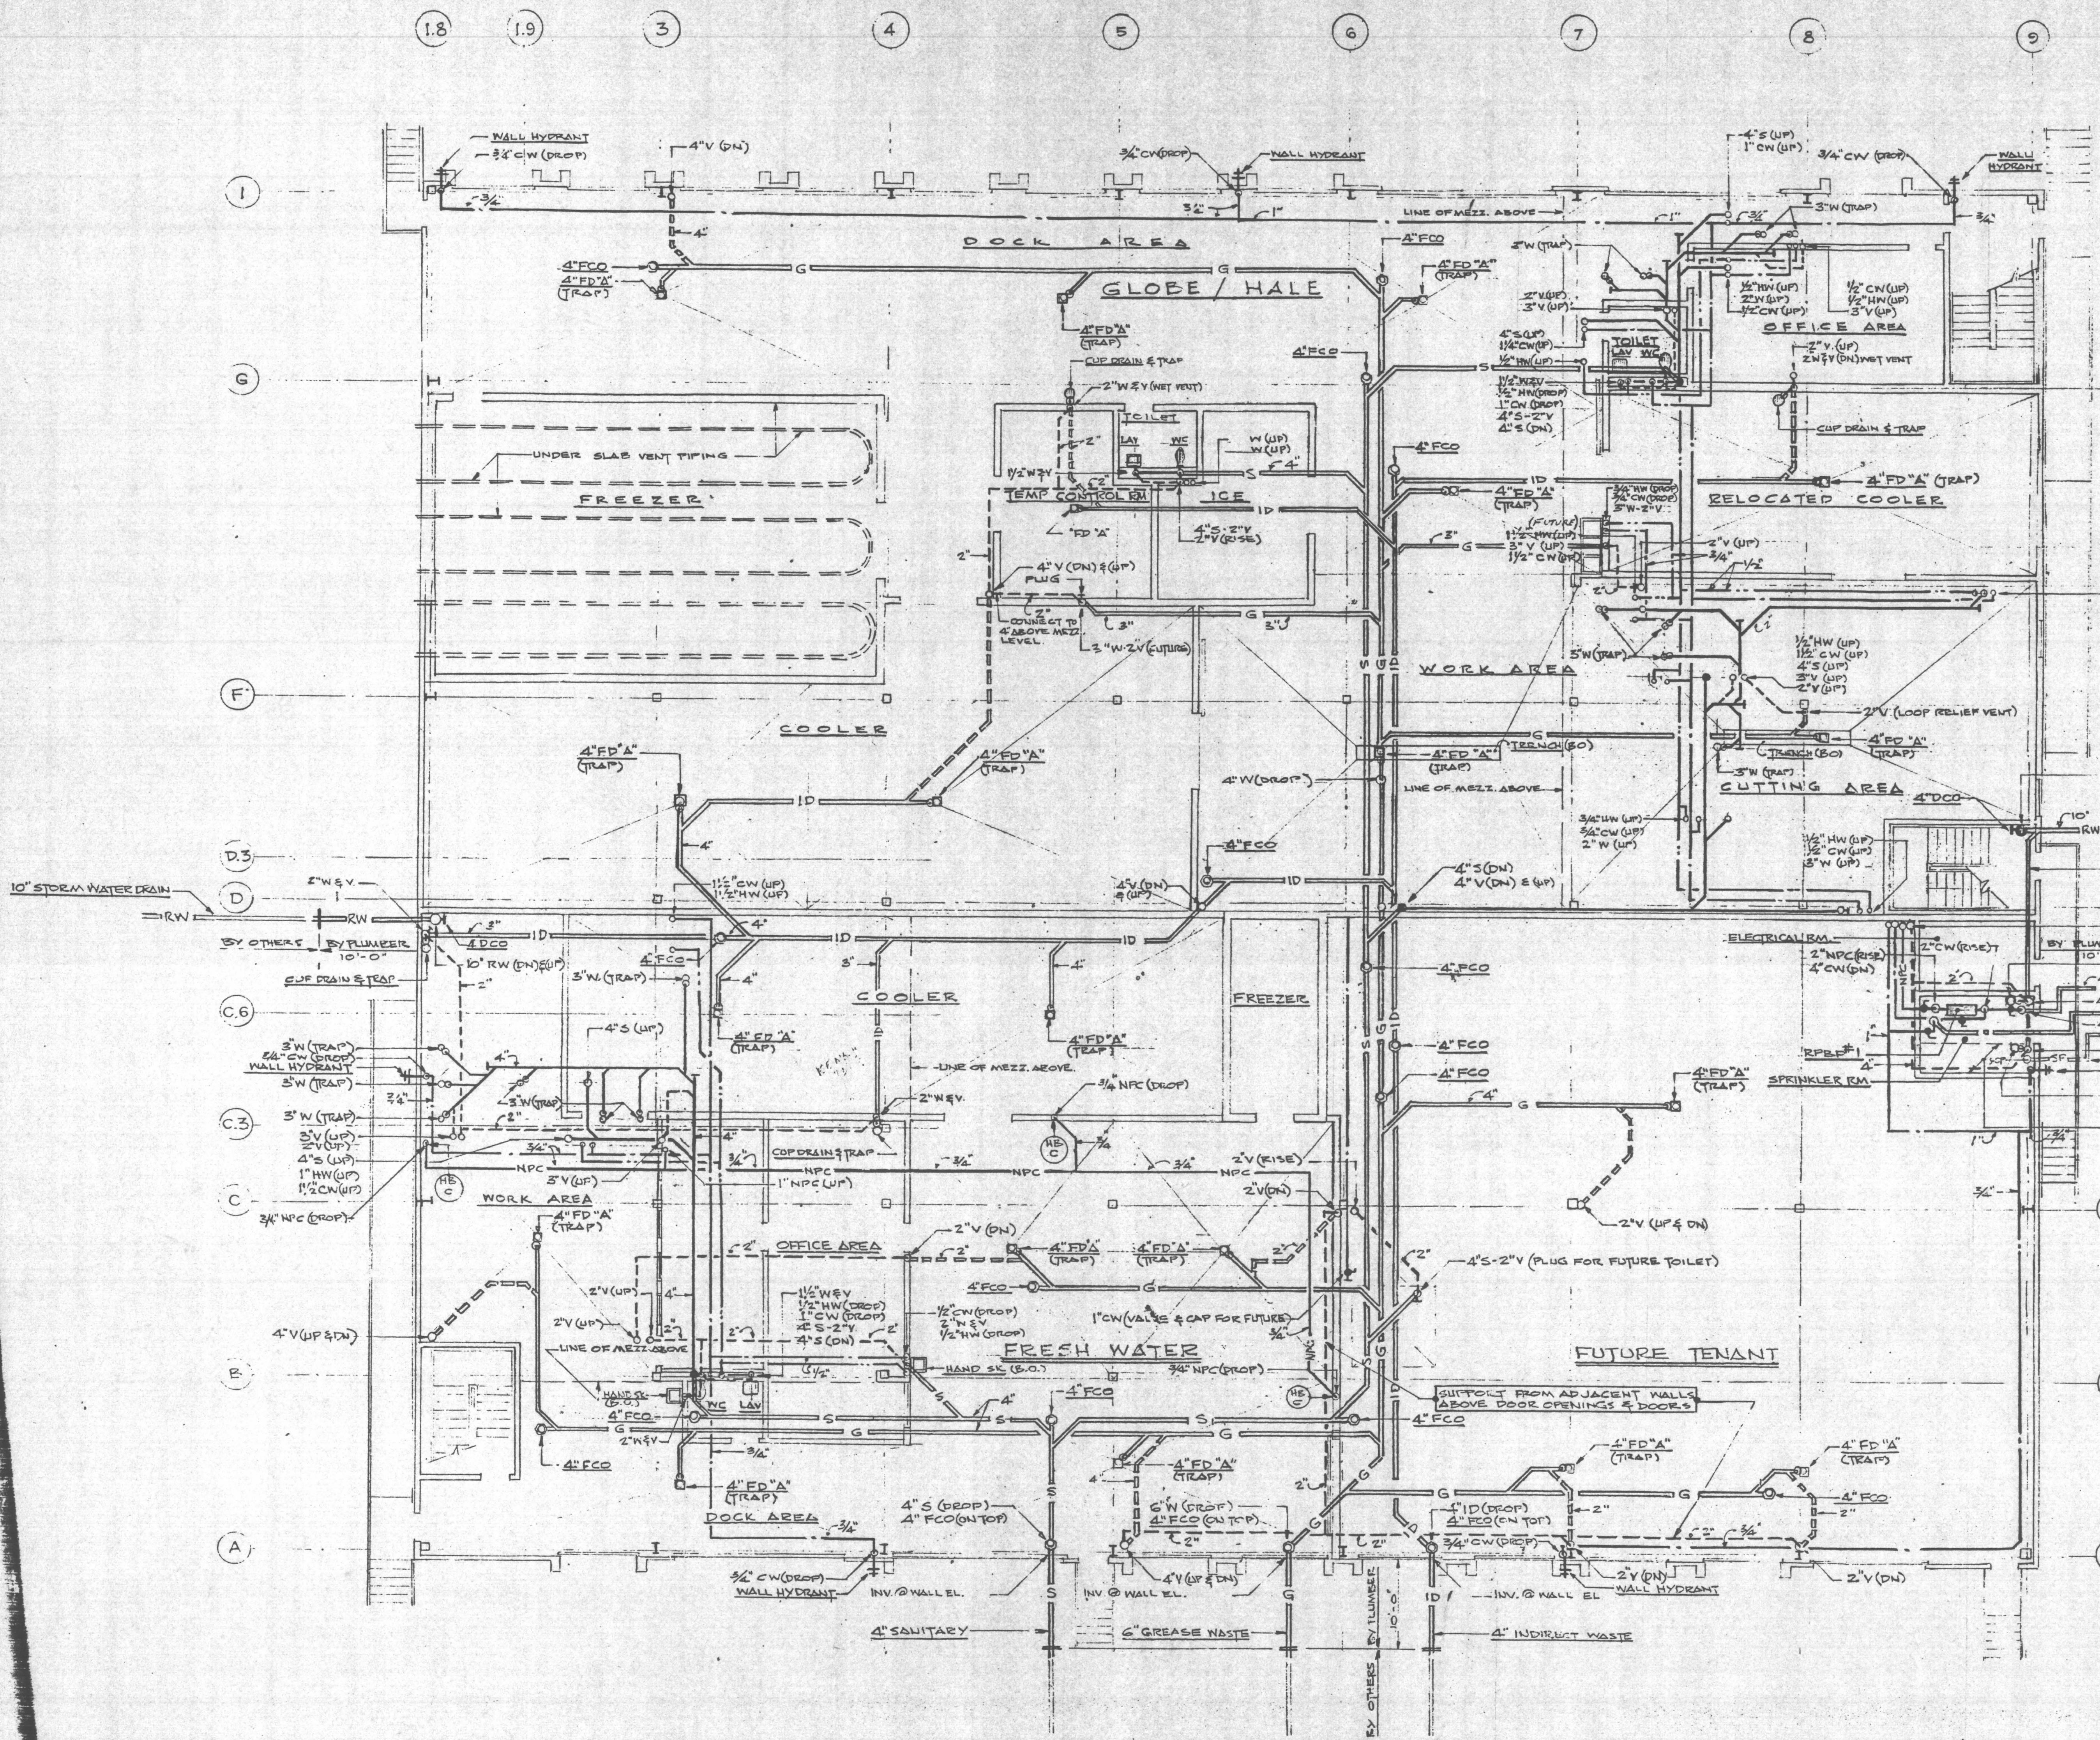
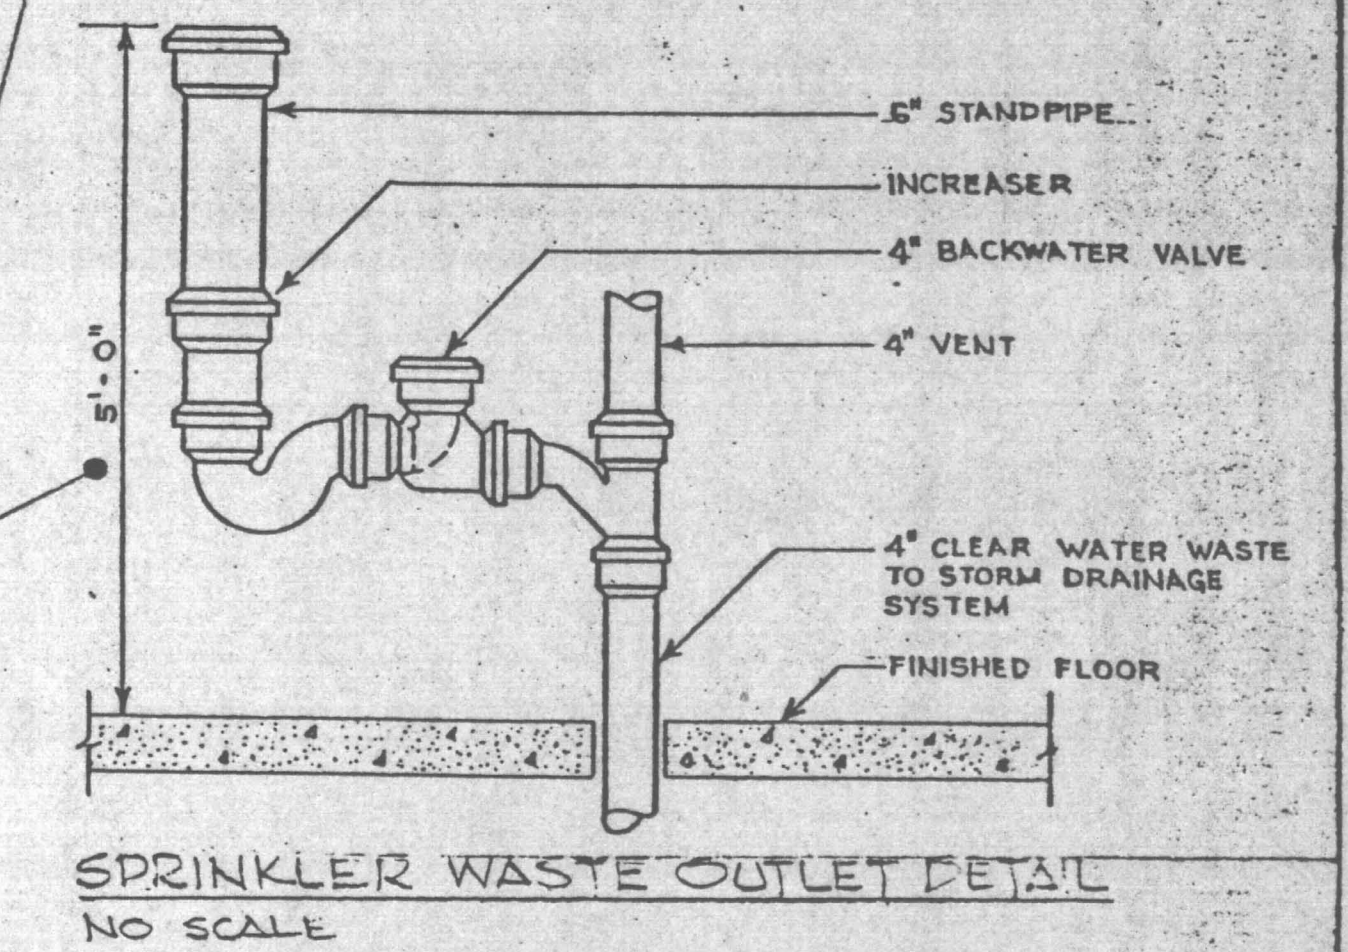


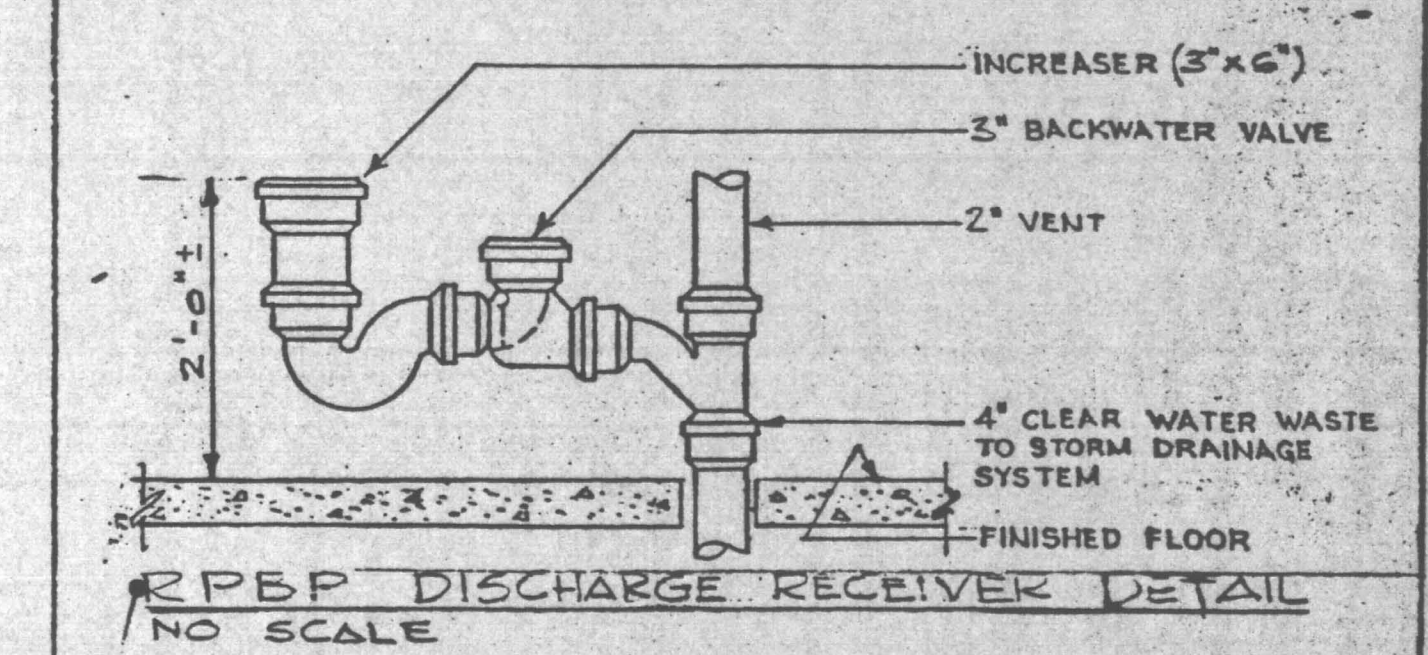


**FIRST FLOOR PLAN
BUILDING #1**
SCALE: 1/8" = 1'-0"

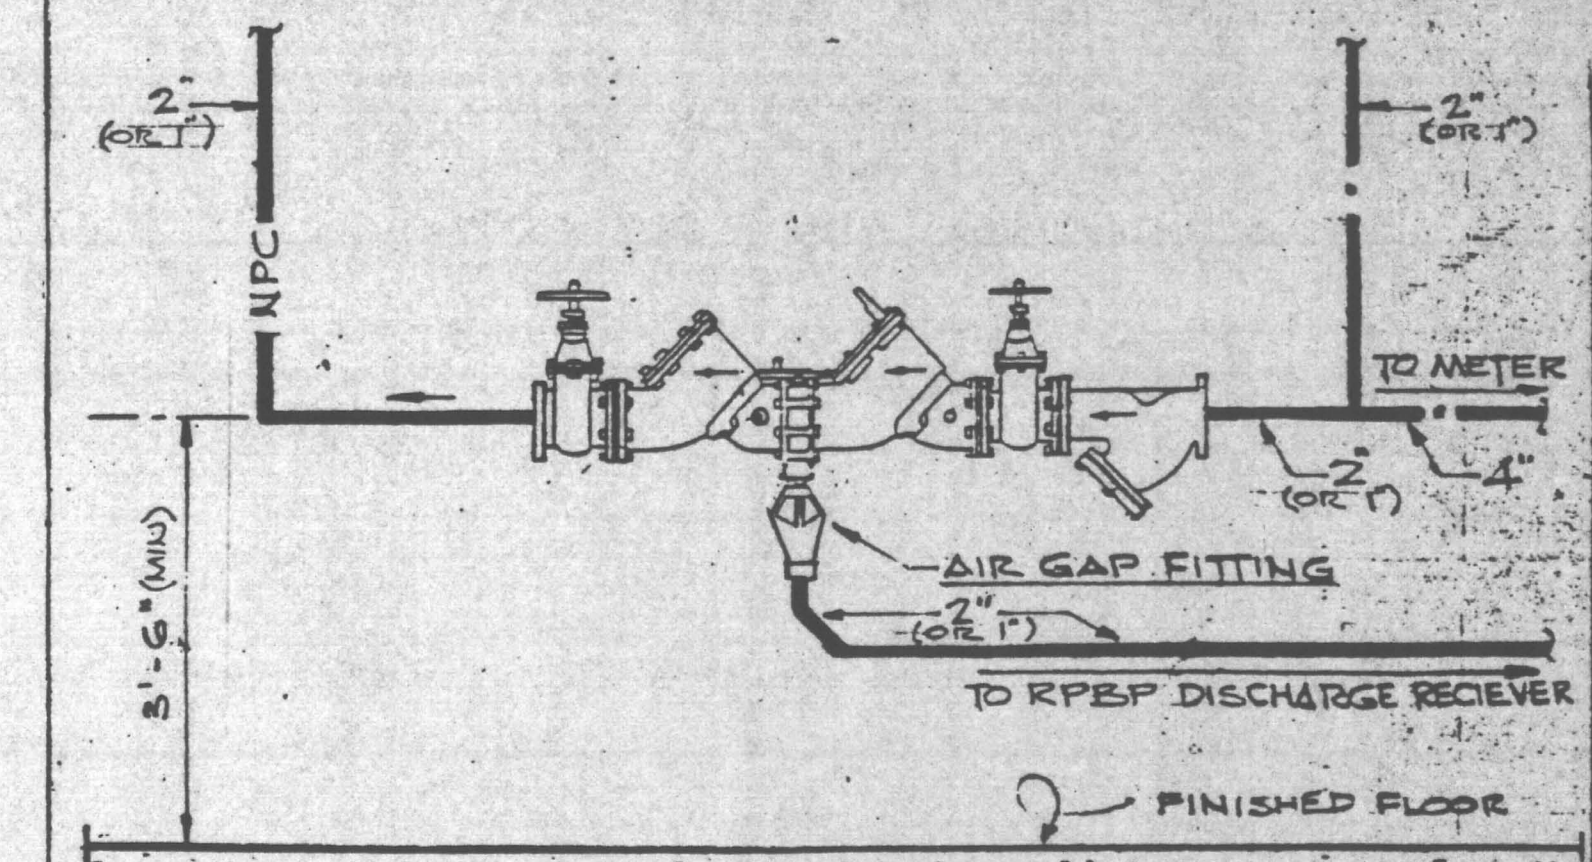

PLUMBING LEGEND		
Below floor & exterior buried piping	DCO	Dandy pattern cleanout
Above floor piping	RPBP	Reduced pressure backflow preventer
Sanitary & waste piping (SAW)	AP	Access panel (by others)
Grease waste piping	BO	By others
Indirect waste piping	WC	Water closet
Rain water piping (RW)	SH	Shower
Vent piping (V)	LAV	Lavatory
Potable cold water piping (CW)	SK	Sink
Non-potable cold water piping (NPC)	FD"A"	Turn -
Non-potable hot water piping (NPH)	FD"B"	Turn - 415
Potable hot water piping (HW)	FD"C"	Turn -
Floor drain	AP	Access panel (by others)
Flush floor cleanout (turn 1400)	INX	Invert
Hot & cold water hose bibb	HB	Cold water hose bibb

As-Built

NEW BOSTON SEAFOOD
EDIC'S MARINE INDUSTRIAL PARK
SOUTH BOSTON, MA

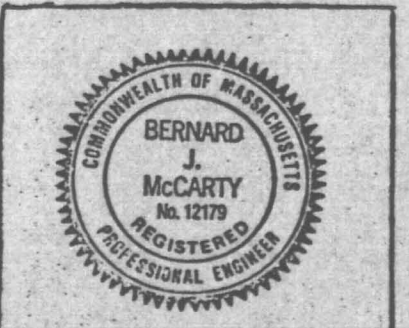

10-22-97
6115
5597
4597
PRELIMINARY 3-5-97

It shall be understood by all concerned that the above registration stamp acknowledges an engineered design for Phase I of this "Design Build" project.

J.F. SHINE MECHANICAL, INC.