
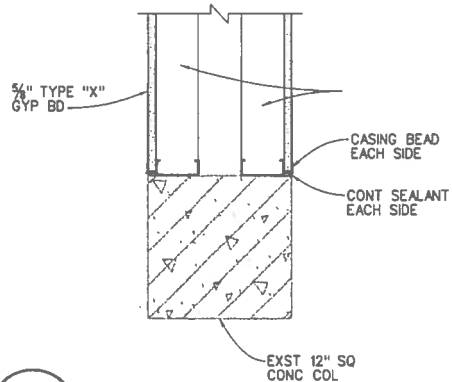



NOTES:

1. SEE DRAWING A1-1 FOR LEGEND & SYMBOLS.
2. SEE DRAWING A1-1 FOR COLOR/MATERIAL SELECTION.

Suites 301, 302 & 303
2,151 sf.
Monthly CAM: \$.64/sf
Electricity & RPT additional cost to Tenant

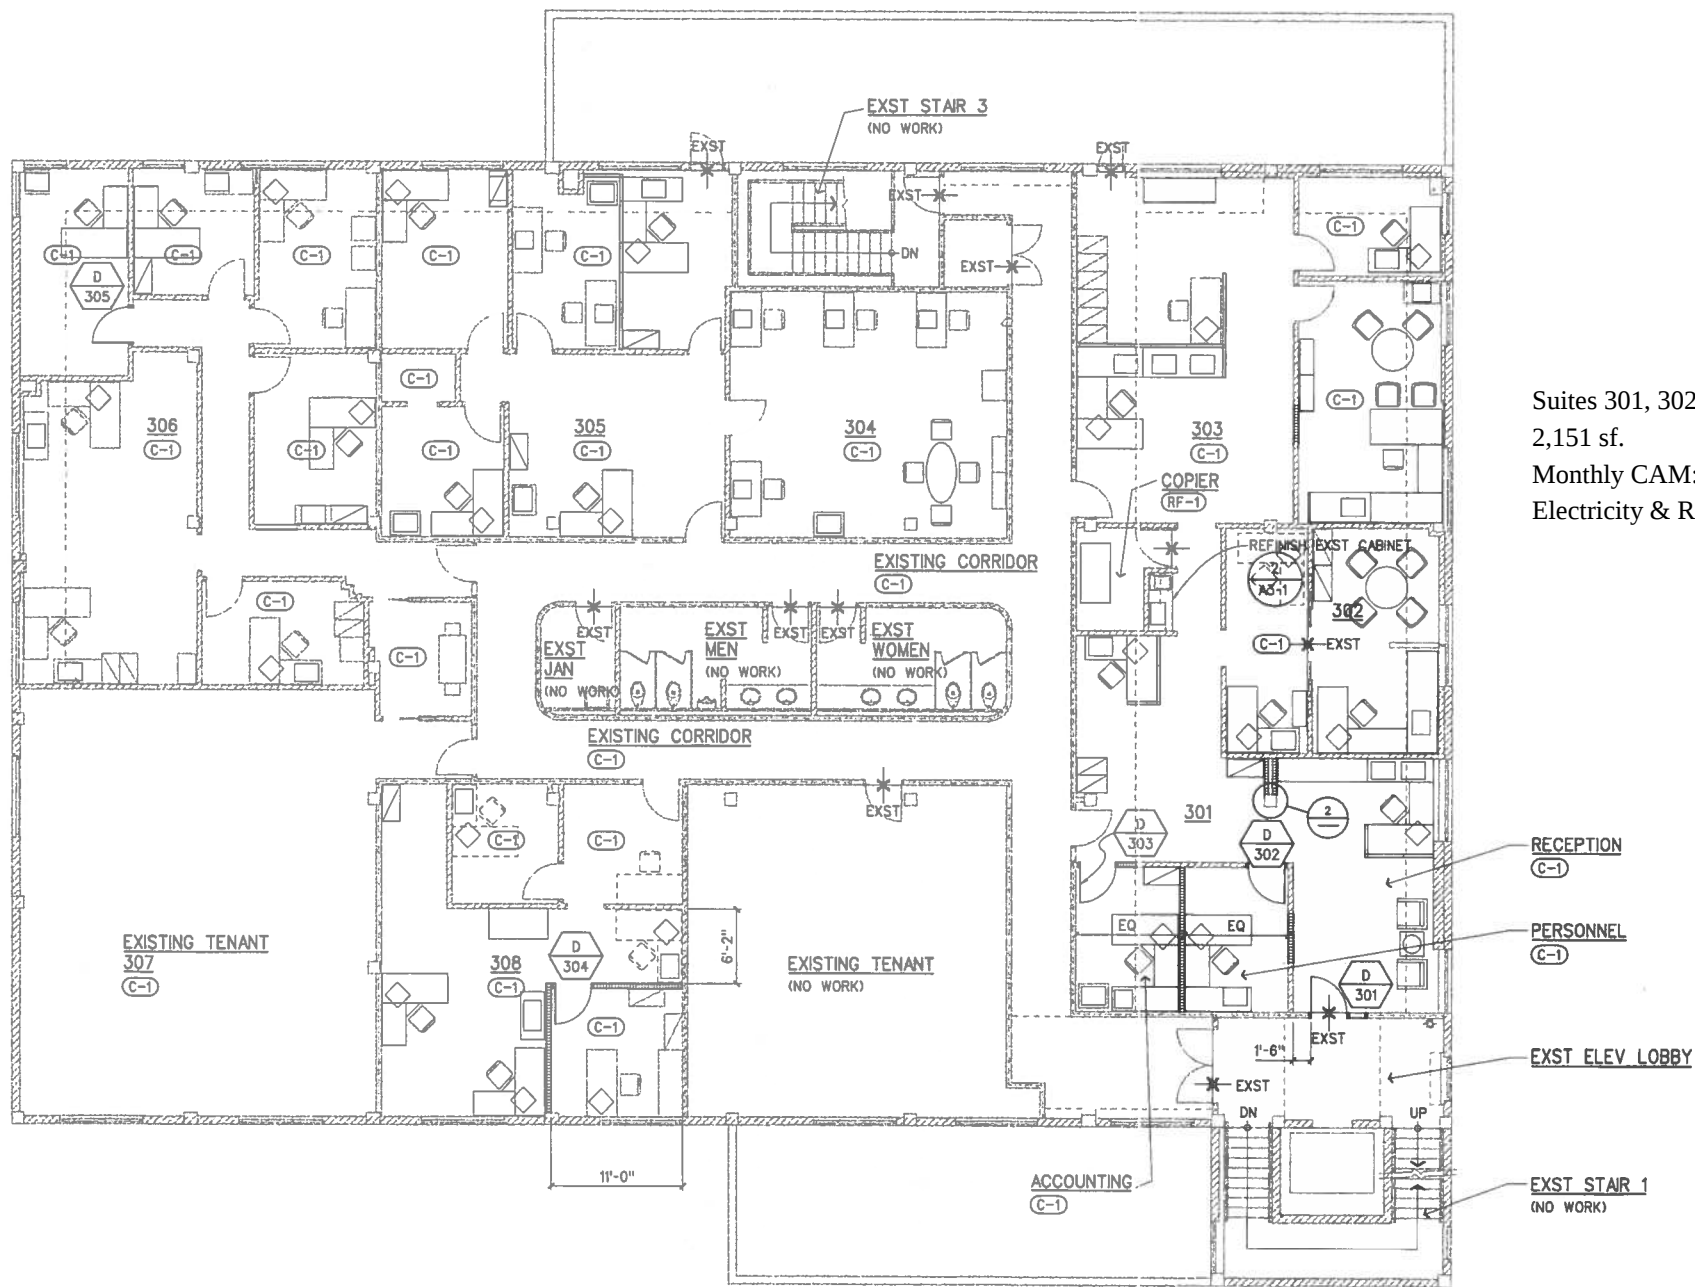

2 DETAIL
1 1/2" = 1'-0"

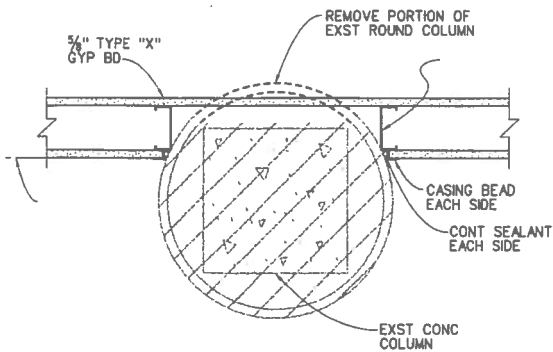

1 DETAIL
1 1/2" = 1'-0"

3RD FLOOR PLAN
1/8" = 1'-0"



This work was prepared by me or under my supervision and construction of this project will be under my observation.

LUERSEN ARCHITECTS INC.
1001 Bishop Street Pauahi Tower
Suite 750 Honolulu HI 96813
Telephone 808-524-1070

Project No. 20005.01
Date 17 SEP 2001


A1-3

H:\20005\005a1-03.opt
09/18/2001 09:11:44 AM
Sheet 8 of 25

**PACIFIC HEALTH
RESEARCH INSTITUTE**

THOMAS SQUARE CENTER, SUITE 303
848 SOUTH HOTEL STREET
HONOLULU, HAWAII 96813

■ 3RD FLOOR REFLECTED
CEILING PLAN

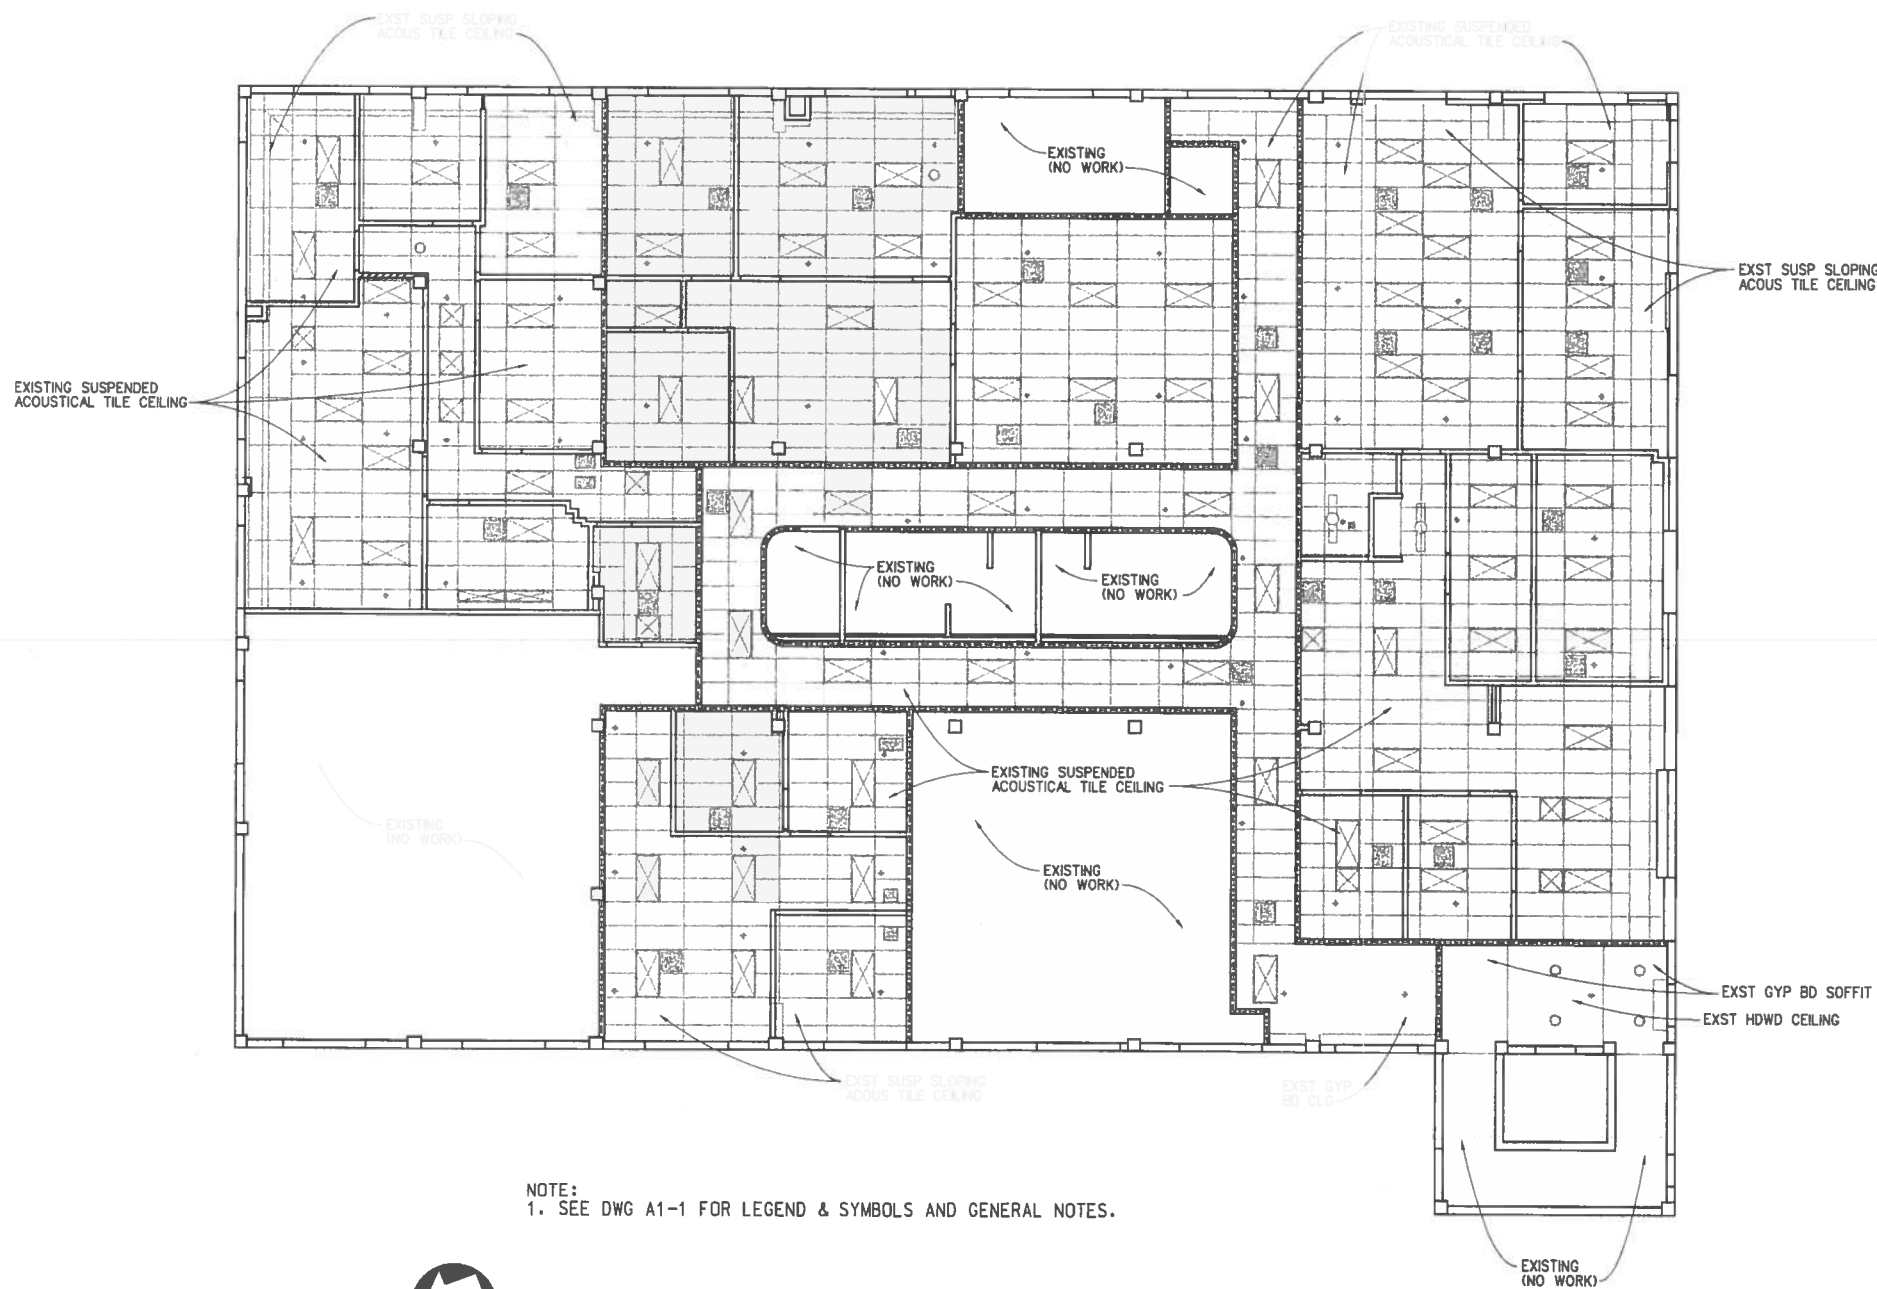

This work was prepared by me
or under my supervision and
construction of this project will
be under my observation.

LUERSEN ARCHITECTS INC.

1001 Bishop Street, Pauahi Tower
Suite 750, Honolulu HI 96813
Telephone 808-524-1070

Project No. 20005.01

Date 17 SEP 2001

A1-4

h:\20005\005a1-04.opt
09/18/2001 09:09:19 AM

Sheet 9 of 25




3RD FLOOR REFLECTED CEILING PLAN
1/8"=1'-0"


2d SECTION

- NOTES:
1. EXISTING BASE AND WALL CABINET:
REMOVE EXISTING FIXED FRONT PANELS AND DOORS
AND REPLACE WITH NEW PLASTIC LAMINATE COVERED
FRONT PANELS AND DOORS (PL-1). MATCH EXISTING
DOOR CONFIGURATIONS.
 2. EXISTING COUNTERTOP:
DISCONNECT EXISTING PLUMBING AT SINK; REMOVE
AND SALVAGE. REMOVE EXISTING COUNTERTOP AND
PROVIDE NEW, MATCHING EXISTING COUNTER PROFILE
(PL-1)


REINSTALL SINK AND PLUMBING FITTINGS UPON
COMPLETION OF COUNTERTOP INSTALLATION.
 3. EXISTING OPEN SHELF:
PREPARE EXISTING SURFACE TO RECEIVE PLASTIC
LAMINATE ON TOP, BOTTOM, SIDES AND EDGES
(PL-1).

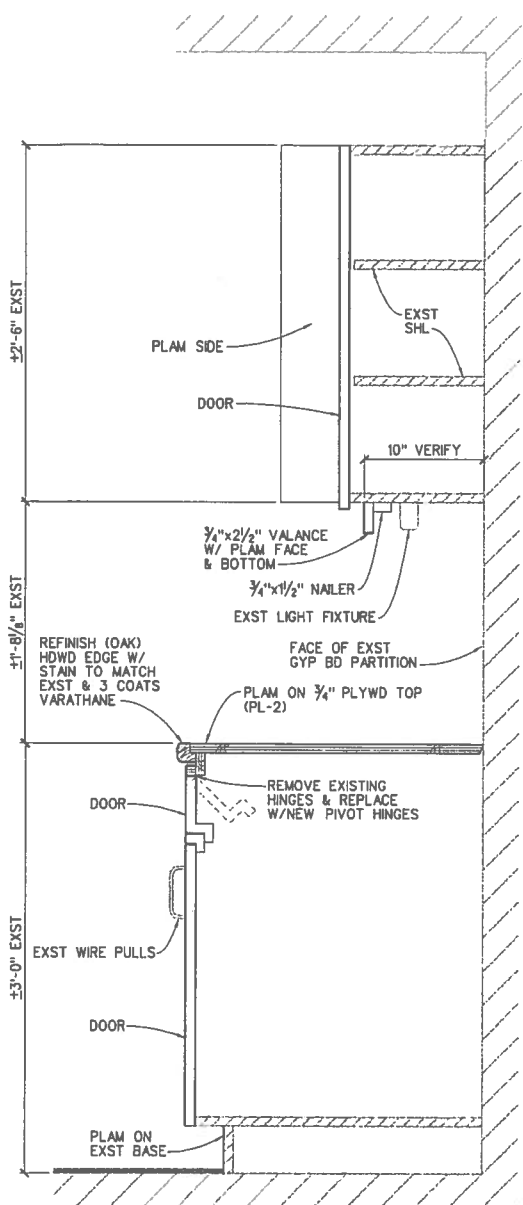

2c SECTION

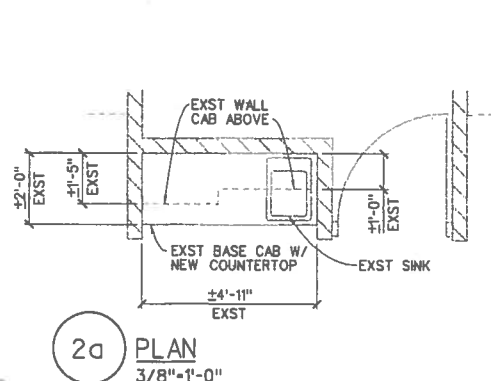


2a PLAN
3/8\"=1'-0\"

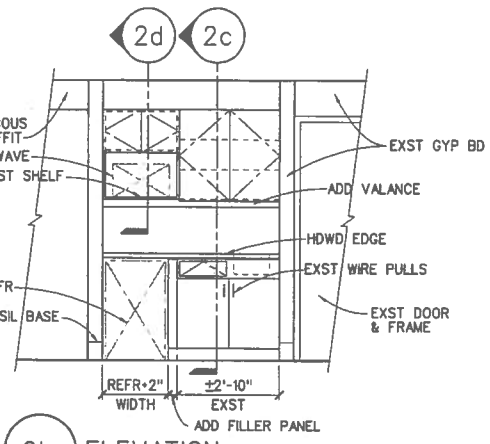

2b ELEVATION
3/8\"=1'-0\"

2 REFINISH EXISTING CABINET
11/2\"=1'-0\" UON

1 PARTITION TYPES
11/2\"=1'-0\"

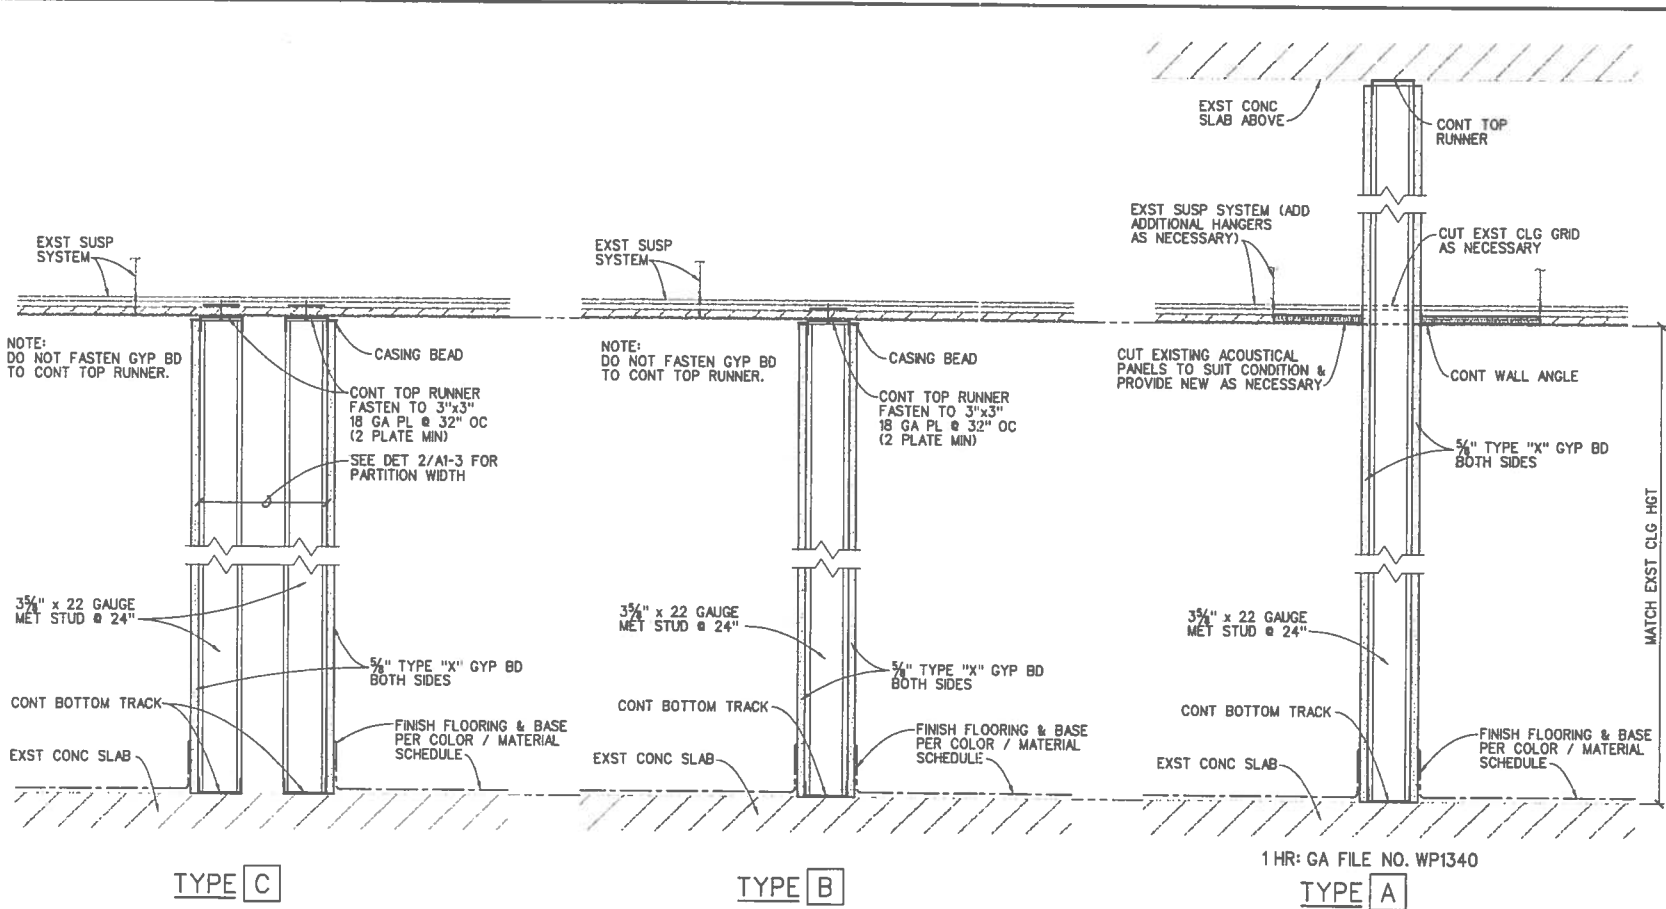

HARDWARE SCHEDULE

CATEGORY	VENDOR NAME	MFG
FLOOR STOP	BY H.B. IVES, INC.	IVE
WALL STOP	BY H.B. IVES, INC.	IVE
HINGE	BY MCKINNEY PRODUCTS COMPANY	MCK
DOOR GASKETING	BY PEMKO	PEM
DOOR CLOSER	BY SARGENT MANUFACTURING COMPANY	SAR
LOCKSET	BY SARGENT MANUFACTURING COMPANY	SAR

HW GROUP - 001			
3.0 EA	HINGE	TA2714 4.5 X 4.5 US10B	MCK
1.0 EA	LOCKSET	21-8243 LNL US10B WBX	SAR
1.0 EA	DOOR CLOSER	1431 0 EB	SAR
1.0 EA	DOOR GASKETING	S44D17	PEM
1.0 EA	FLOOR STOP	436B10B 435A	IVE

HW GROUP - 002			
3.0 EA	HINGE	TA2714 4.5 X 4.5 US10B	MCK
1.0 EA	LOCKSET	21-8243 LNL US10B WBX	SAR
1.0 EA	DOOR CLOSER	1431 0 EB	SAR
1.0 EA	DOOR GASKETING	S44D17	PEM
1.0 EA	WALL STOP	407B10B	IVE

HW GROUP - 003			
3.0 EA	HINGE	TA2714 4.5 X 4.5 US10B	MCK
1.0 EA	LOCKSET	21-28-10G05 LL US10B WBX	SAR
1.0 EA	DOOR CLOSER	1431 P9 EB	SAR
1.0 EA	DOOR GASKETING	S44D17	PEM
1.0 EA	WALL STOP	407B10B	IVE

HW GROUP - 004			
3.0 EA	HINGE	TA2714 4.5 X 4.5 US10B	MCK
1.0 EA	LOCKSET	21-28-10G05 LL US10B WBX	SAR
1.0 EA	DOOR CLOSER	1431 0 EB	SAR
1.0 EA	DOOR GASKETING	S44D17	PEM
1.0 EA	WALL STOP	407B10B	IVE

HW GROUP - 005			
3.0 EA	HINGE	TA2714 4.5 X 4.5 US10B	MCK
1.0 EA	LOCKSET	21-28-10G05 LL US10B WBX	SAR
1.0 EA	WALL STOP	407B10B	IVE



This work was prepared by me
or under my supervision and
construction of this project will
be under my observation.


LUERSEN ARCHITECTS INC.
1001 Bishop Street Paohi Tower
Suite 750 Honolulu HI 96813
Telephone 808-524-1070

Project No. 20005.01
Date 17 SEP 2001

**PACIFIC HEALTH
RESEARCH INSTITUTE**

THOMAS SQUARE CENTER, SUITE 303
846 SOUTH HOTEL STREET
HONOLULU, HAWAII 96813


■ 3RD FLOOR
AIR CONDITIONING PLAN

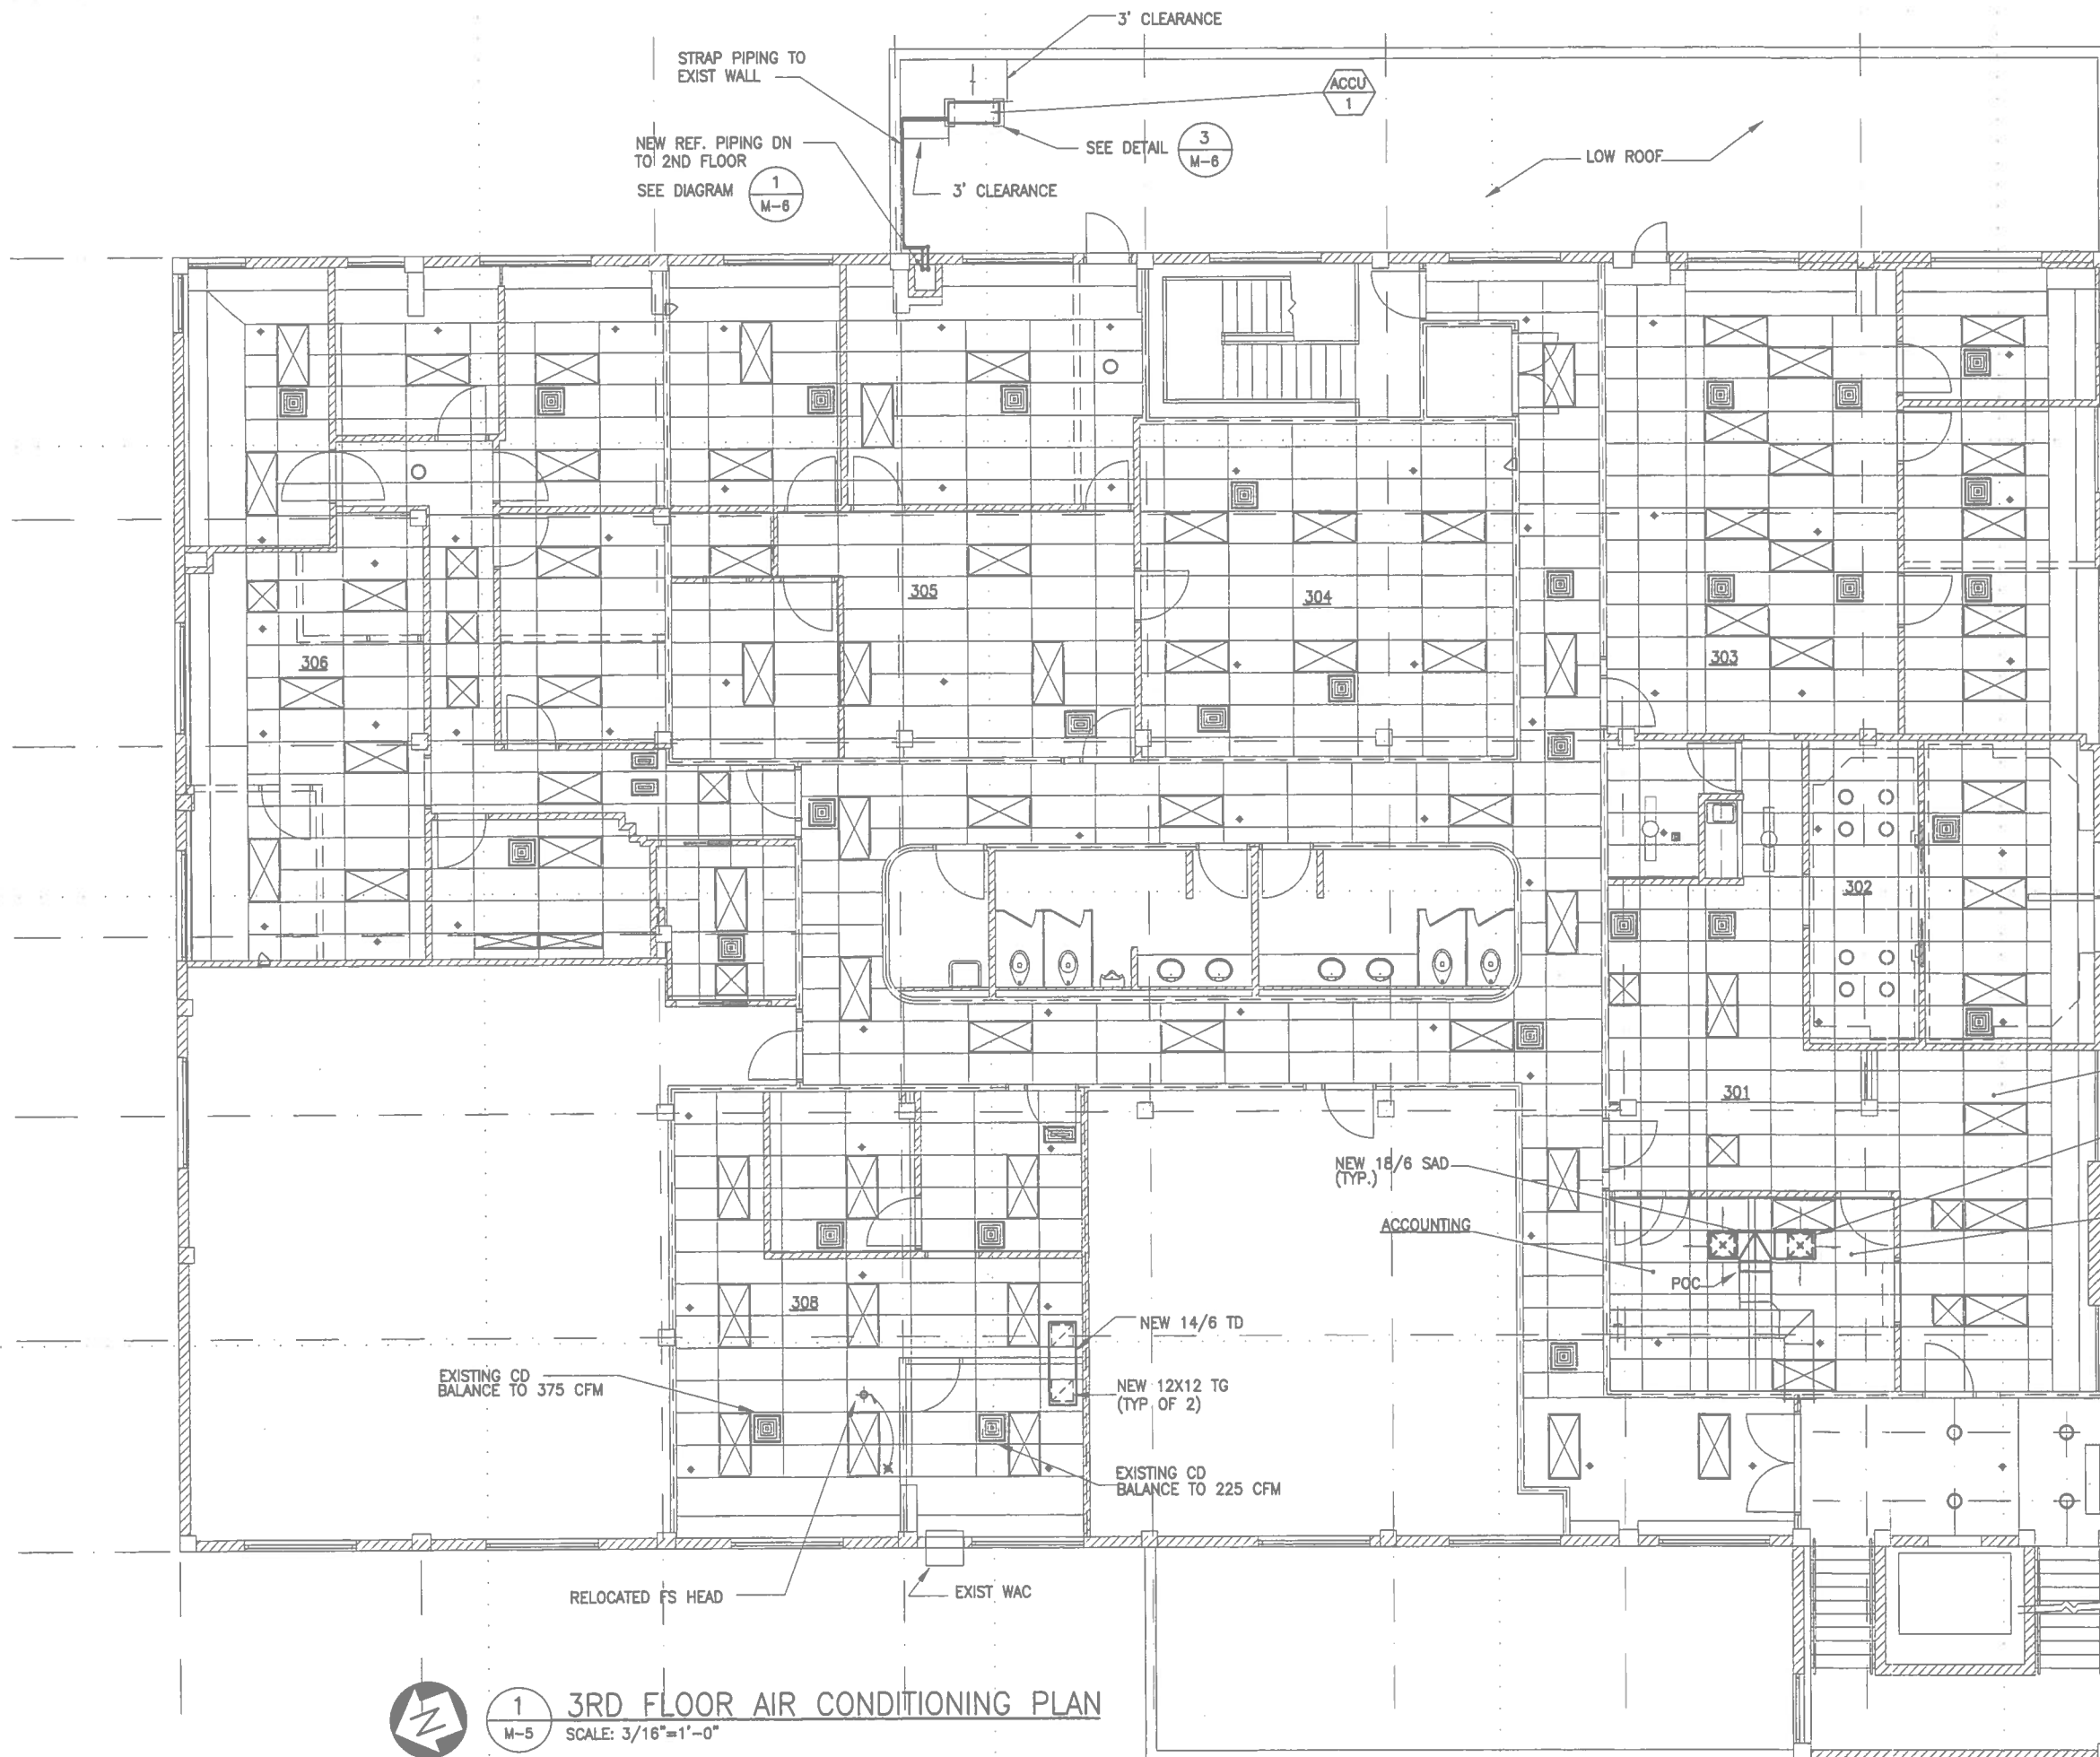

1
M-5

3RD FLOOR AIR CONDITIONING PLAN

SCALE: 3/16"=1'-0"

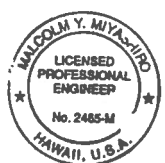

Malcolm Y. Miyashiro

This work was prepared by me
or under my supervision and
construction of this project will
be under my observation.

LUERSEN ARCHITECTS INC.

1001 Bishop Street Paohi Tower
Suite 750 Honolulu HI 96813
Telephone 808-524-1070

Project No. 20005.01

Date SEPTEMBER 17, 2001

M-5

FILES	DATES	TIMES
Sheet 16	of 25	



SCALE: 1/8" = 1'-0"

1 REPLACE EXISTING LOADCENTER WITH NEW FLUSH 16 CIRCUIT LOADCENTER. 120/208V, 1 ϕ -3W. RECONNECT EXISTING FEEDER AND BRANCH CIRCUITS. PROVIDE 1P20A BREAKERS IN ALL UNUSED CIRCUITS.


This work was prepared by me or under my supervision and construction of this project will be under my observation.

LUERSEN ARCHITECTS INC.
1001 Bishop Street Paahi Tower
Suite 750 Honolulu HI 96813
Telephone 808-524-1070

Project No. 20005.01

Date 17 SEP 2001


E-7

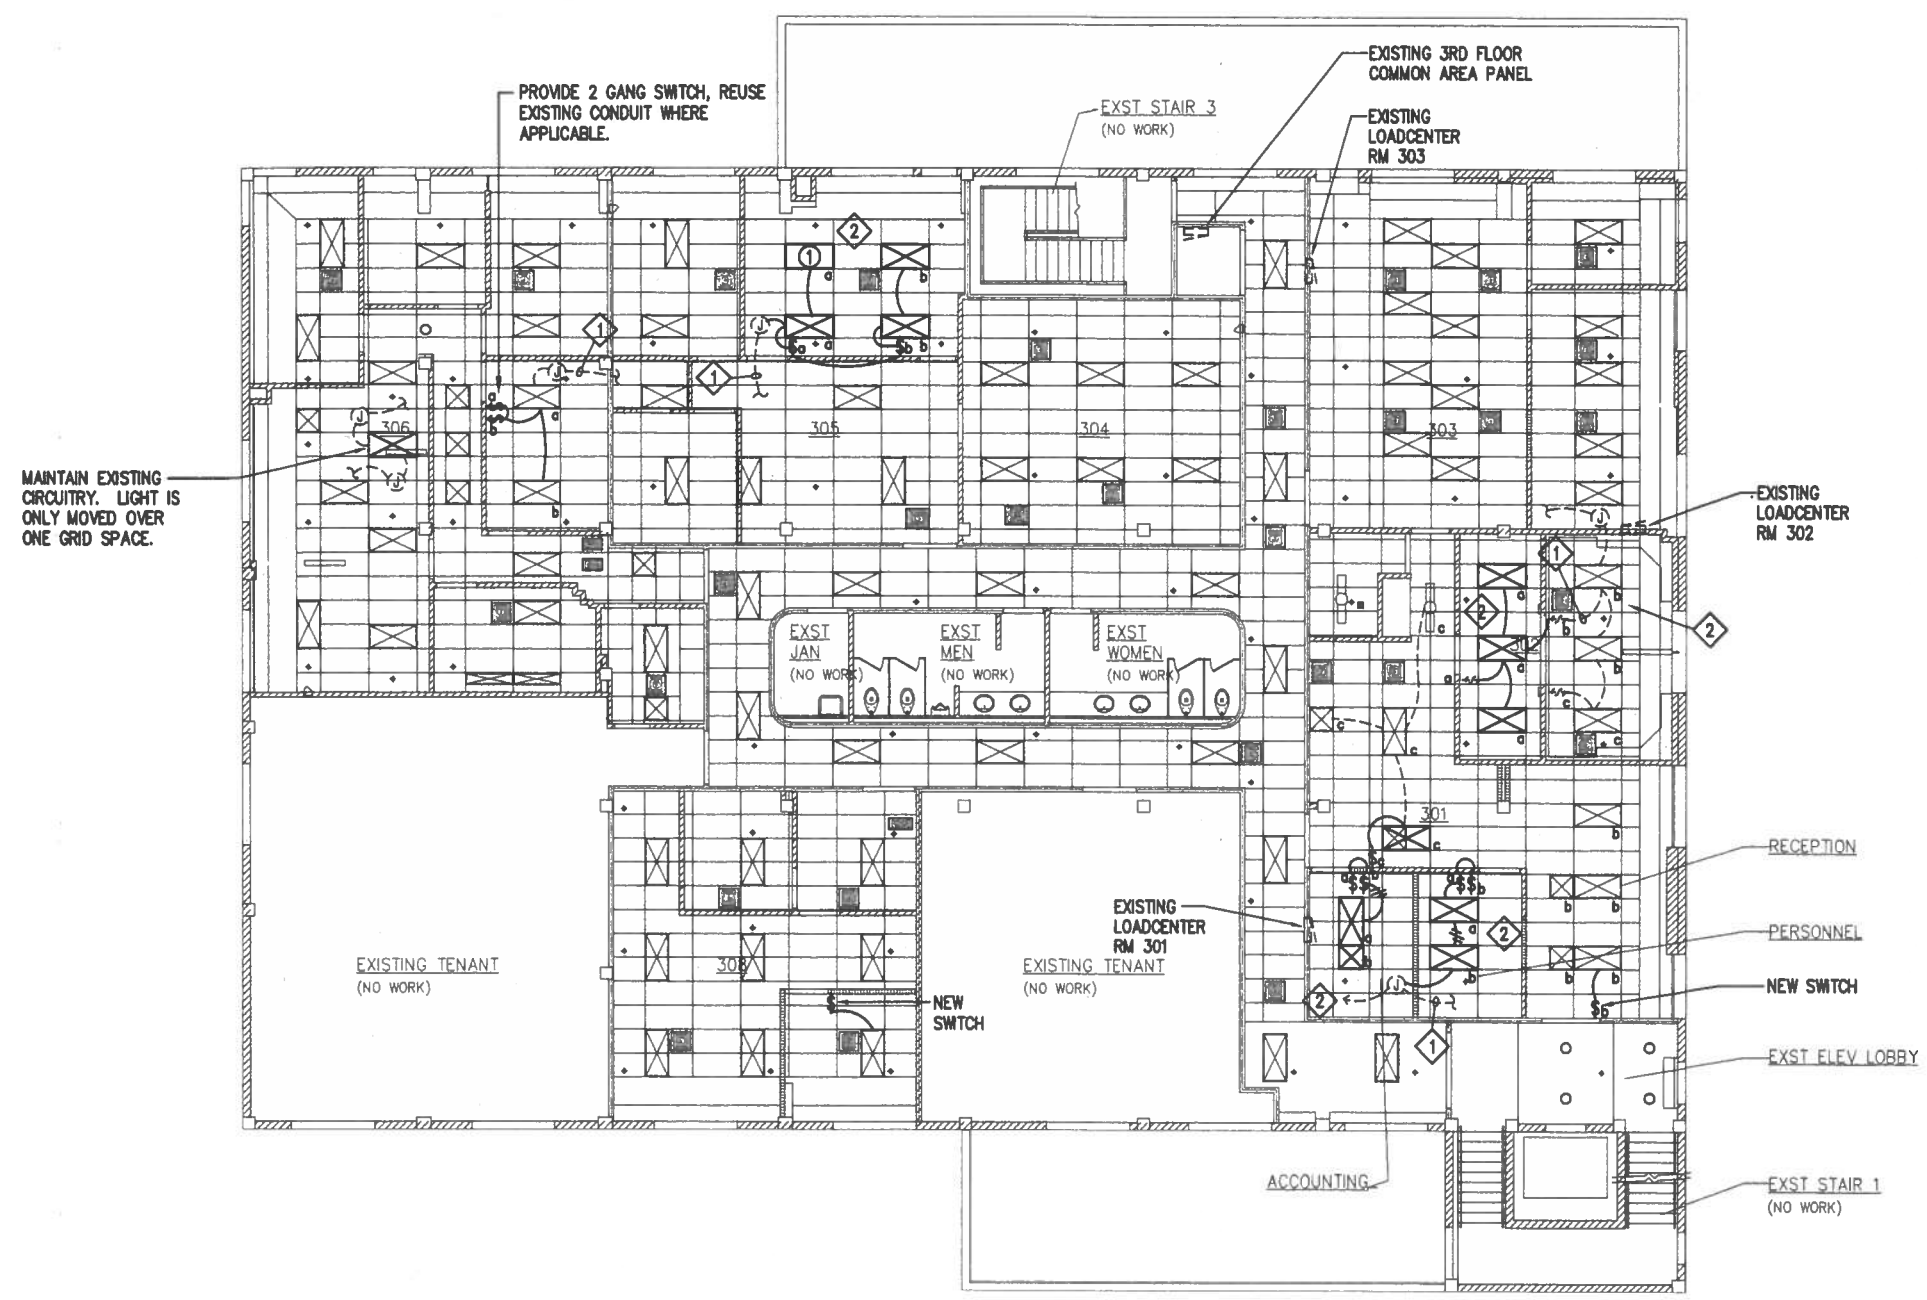

3RD FLOOR LIGHTING PLAN
SCALE: 1/8" = 1'-0"

NOTES:

- 1 VERIFY EXISTING CIRCUITING. CONNECT RELOCATED LIGHTS TO VERIFIED CIRCUIT.
- 2 PROVIDE NEW PRISMATIC LENSES FOR ALL LUMINAIRES IN THIS ROOM DISPOSE OF ALL REMOVED LENSES.

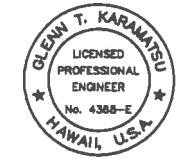

Glenn Karamatsu

This work was prepared by me or under my supervision and construction of this project will be under my observation.

LUERSEN ARCHITECTS INC.
1001 Bishop Street Paohi Tower
Suite 750 Honolulu HI 96813
Telephone 808-524-1070

Project No. 20005.01
Date 17 SEP 2001