



1
A1.1 REVISED REFLECTIVE CEILING PLAN
SCALE 3/16"=1'-0"

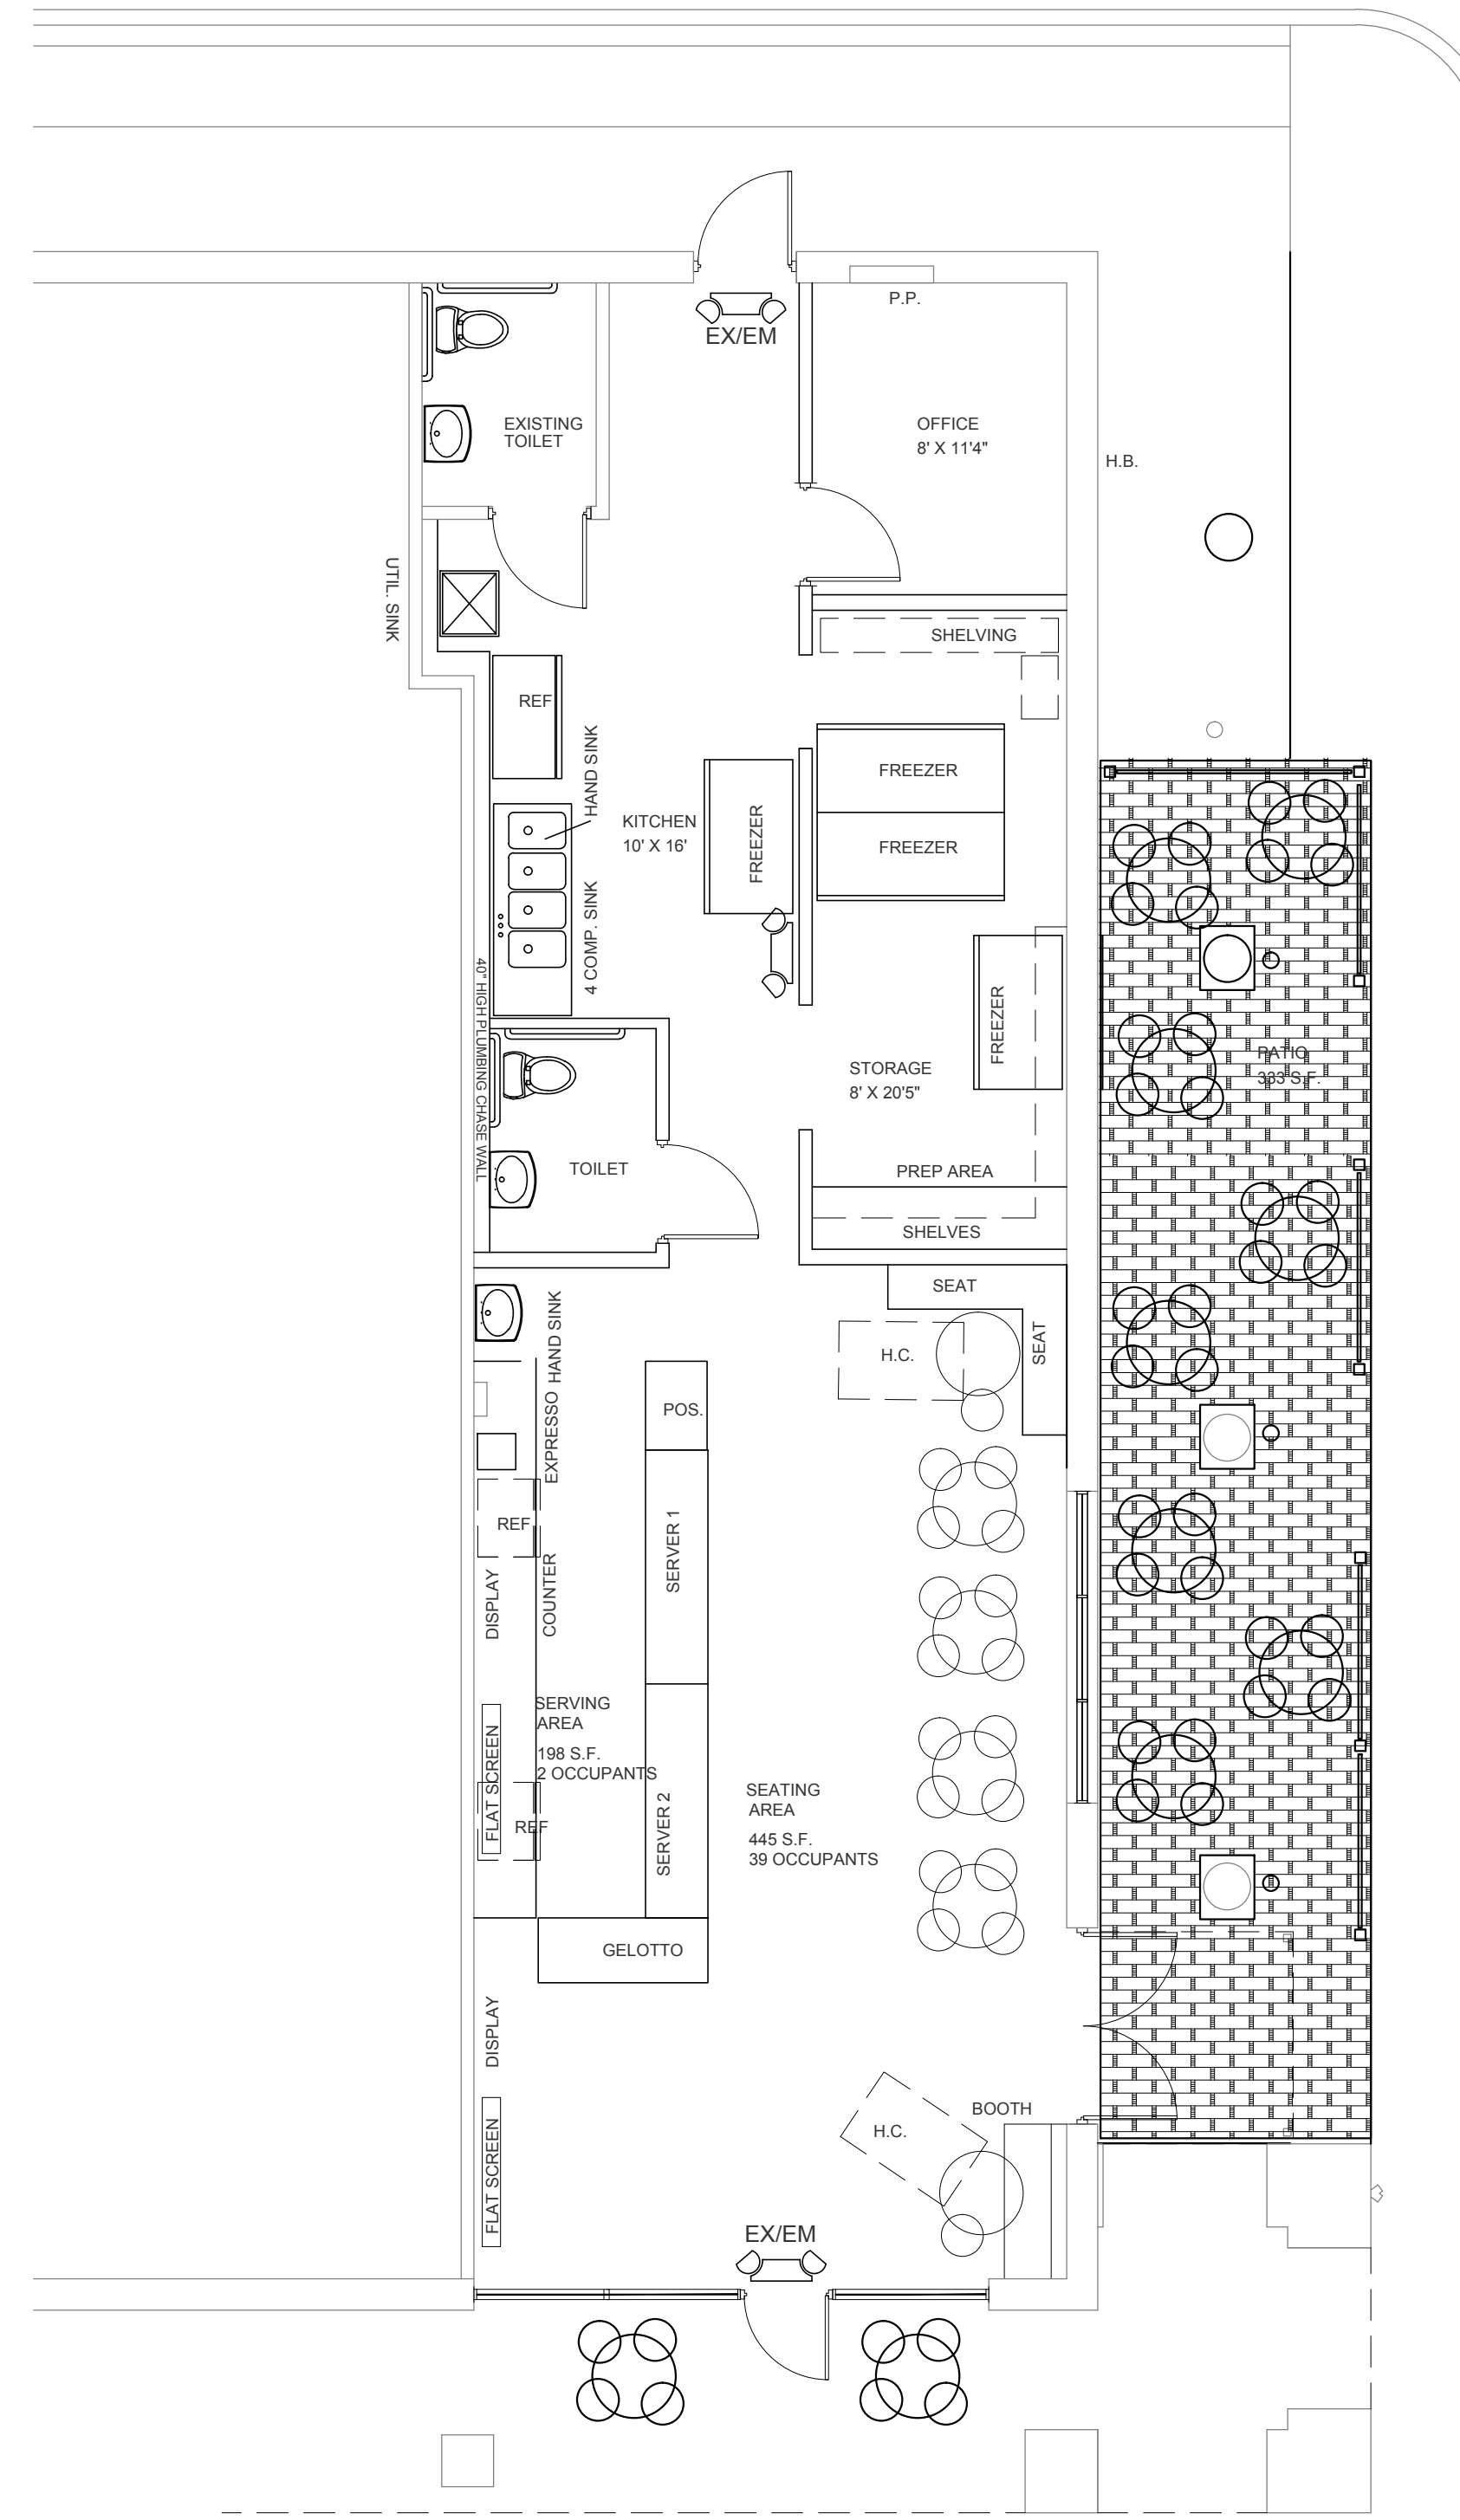

2
A1.1 REVISED FLOOR PLAN
SCALE 3/16"=1'-0"

CEILING LEGEND	
	CHANDELIER FIXTURE BY OWNER
	SMALL PENDANT FIXTURE BY OWNER
	2 X 4 LAYIN FIXTURE
	6" RECESSED SPOT LIGHT
	2 X 2 SA DIFFUSER
	2 X 2 RA DIFFUSER
	1 X 2 SA DIFFUSER
	EXHAUST FAN
	EXIT LIGHT / EMERGENCY LIGHT COMBINATION PACKAGE
	TRACK LIGHT BY OWNER

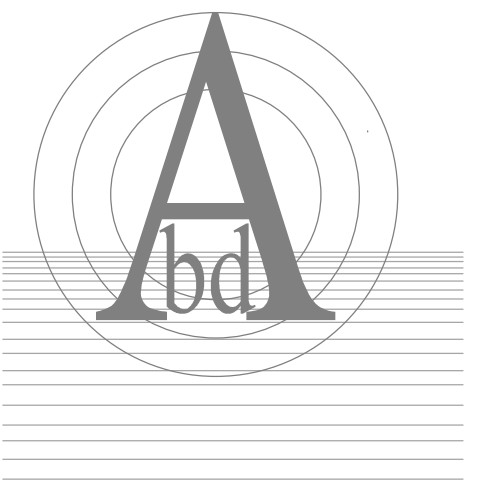

Bruce D. Amalfitano, A.I.A.
architect
 11579 McCormick Road, Jacksonville, Florida 32225
 bamalfi@aam.com 904 228 9337

#AR 0009774
 3 FEBRUARY 2017

TENANT IMPROVEMENT
LE MACARON
330 RT. A1A SUITE 300
Jacksonville, Florida

DATE	DRAWN BY	REVISIONS
09-23-2016		

A1.1