


NOTES:
 BELVEDERE USA, LLC RECEIVES BUILDING INFORMATION IN ELECTRONIC, BLUEPRINT OR FIELD MEASUREMENT FORM. BELVEDERE USA LLC ASSURES NO RESPONSIBILITY OR LIABILITY FOR DAMAGES OR CLAIMS ARISING OUT OF THE ACCURACY OF MEASUREMENTS SUBMITTED TO US BY OTHERS NOR FOR CORRECT LOCATION OR DEPTH OF ELECTRICAL SERVICE, NOR FOR ANY CODE REQUIREMENTS. PLUMBING MEASUREMENTS ON THIS PLAN ARE FOR ROUGH ONLY. BELVEDERE USA LLC ASSURES NO RESPONSIBILITY FOR THE ACCURACY OF THE GENERAL CONTRACTOR'S TO VERIFY ALL MEASUREMENTS AND CLEARANCES AND TO VERIFY COMPLIANCE WITH ADA STANDARDS, STATE AND LOCAL CODES GOVERNING ELECTRICAL, PLUMBING, HVAC, AND FIRE SAFETY STANDARDS, ZONING, CONSTRUCTION, ETC.
 THE ELECTRICAL AND PLUMBING PLAN IS FOR BELVEDERE USA LLC EQUIPMENT. SOME EQUIPMENT IS NOT SHOWN AND BELVEDERE USA LLC ASSURES NO LIABILITY FOR EQUIPMENT NOT INCLUDED ALL THAT IS REQUIRED BY CODES ALL ELECTRICAL AND PLUMBING MUST MEET STATE AND LOCAL CODES, AND BE SUPPLIED BY ARCHITECT/CONTRACTOR/OWNER.
 MEASUREMENTS SHOULD BE CHECKED WITH THE ARCHITECT OR PROPER CONTRACTOR AND NOTIFY BELVEDERE USA LLC OF ANY DISCREPANCIES BEFORE WORK IS STARTED.
 ALL SWITCHES LOCATION AND CONTROLS ARE TO BE SPECIFIED BY CONTRACTOR & OWNER. VERIFY WITH OWNER, THE REQUIREMENTS FOR PROVIDING BLOCKING, WHERE INDICATED FOR CEMENTARY, HEIGHT TO CENTERLINE.
 THE INFORMATION DOCUMENTED IN THIS PLAN IS TO BE VIEWED AS A SUGGESTION ONLY. BELVEDERE USA LLC ASSURES NO RESPONSIBILITY OR LIABILITY FOR DAMAGES OR CLAIMS RESULTING OUT OF THE ACCURACY OF THIS PLAN. BELVEDERE USA LLC SUGGESTS THAT THIS DRAWING BE REVIEWED BY A LOCAL ARCHITECT FOR ADDITIONAL EXAMINATION OF THE EXISTING BUILDING CONDITIONS AND OVERALL APPLICATION.

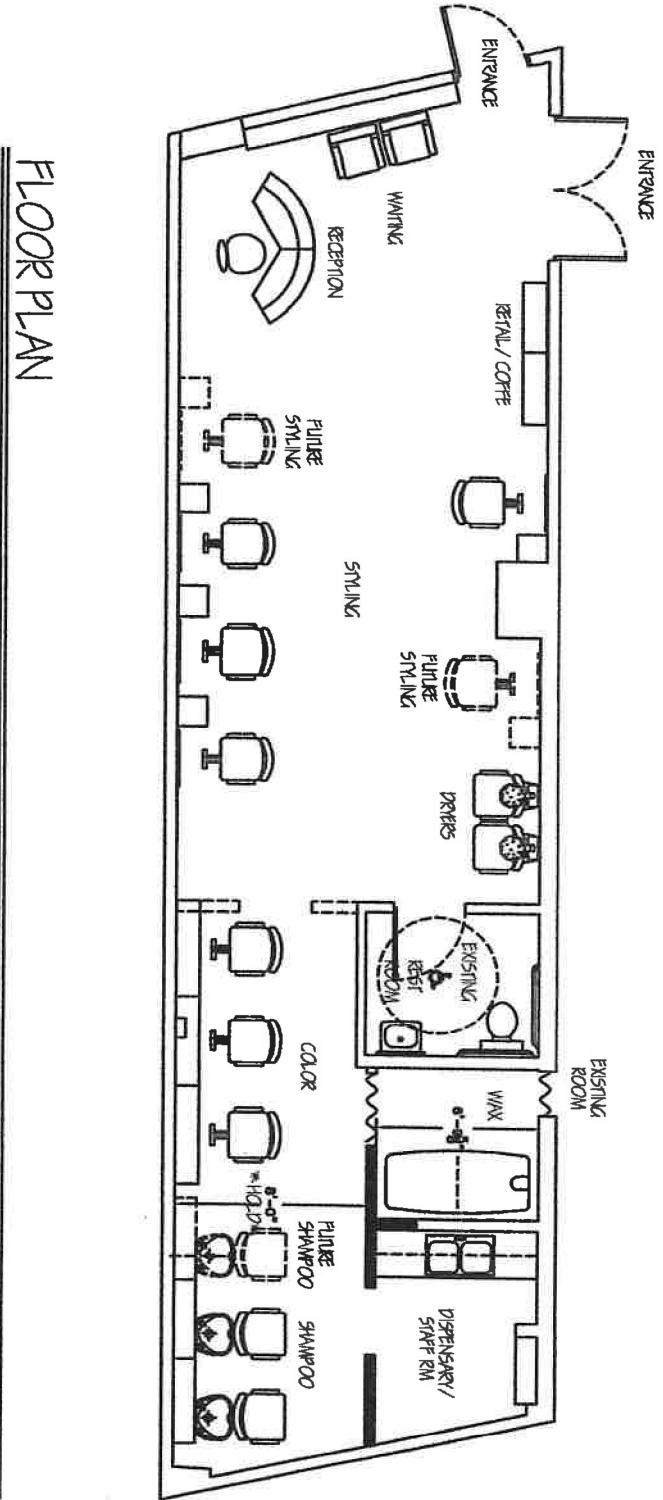

FLOOR PLAN

WALL KEY

[Solid Line]	New Walls
[Dashed Line]	Existing Walls
[Dotted Line]	Partial Walls
[Cross-hatched]	Walls to be Removed

belvedere INTERIOR DESIGN GROUP ONE BELVEDERE BOULEVARD BELVEDERE ILLINOIS 61008		PROJECT NAME: BARBARA DASHIELL SALON 244 GLEN COVE AVE GLEN COVE, NY 11542	OWNER: BARBARA DASHIELL
CAD AND PLOT COORDINATOR DATE: 12-21-08 SCALE: 1/4" = 1'-0" DESIGNED BY: TO CHECKED BY: TO SHEET TITLE: FLOOR PLAN	DESCRIPTION: Design Development	REVISIONS: NO. 1 DESCRIPTION:	NO. 1 DESCRIPTION: