


A6

A9

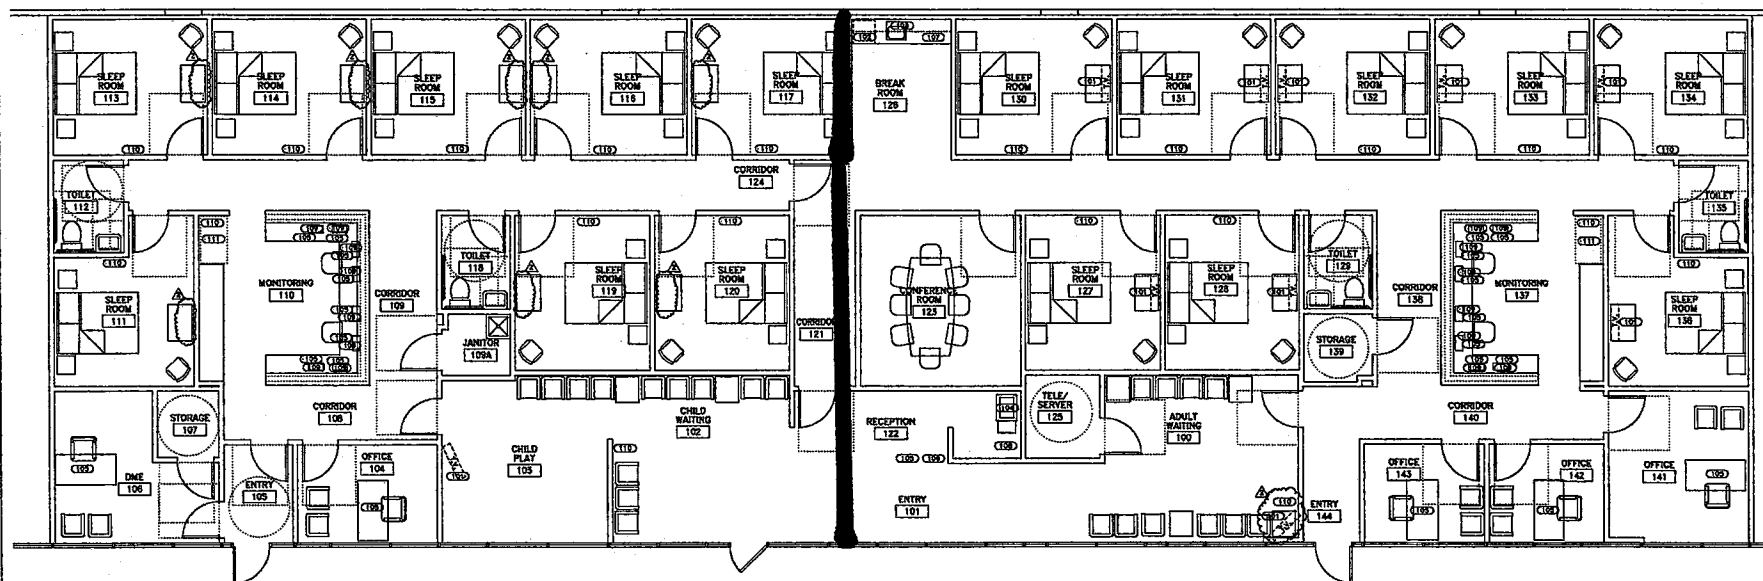

Curry Boudreaux Architects

5009 Caroline • Suite 200
Houston, Texas 77004
T • 713.523.8787
F • 713.523.8785

CBA Project No. 2006-0005

Sleep Development Group

Sleep Lab - S. Main

MAIN MEDICAL PLAZA
10019 S. MAIN • SUITE A-9
HOUSTON, TX 77025

Issued: 27 APRIL, 2006
FOR PERMIT

Revisions:
▲ ADDENDUM #1 15 MAY, 2006
▲ ADDENDUM #2 18 MAY, 2006



EQUIPMENT PLAN GENERAL NOTES

1. GENERAL CONTRACTOR TO VERIFY CLEARANCES REQUIRED FOR ALL EQUIPMENT AND TO VERIFY LOCATION OF ALL EQUIPMENT WITH OWNER PRIOR TO INSTALLATION.
2. ALL FURNITURE SHOWN IS TENTATIVELY FURNISHED, TURNOUT INSTALLED.

EQUIPMENT LIST

- 113 TELEVISION - T.F.S.A. ▲
- 114 U.C. REFRIGERATOR - T.F.S.A.
- 115 MICROWAVE - T.F.S.A.
- 116 COFFEE - T.F.S.A.
- 117 COMPUTER - T.F.S.A.
- 118 PRINTER - T.F.S.A.
- 119 COFFEE MAKER - T.F.S.A.
- 120 FAX MACHINE - T.F.S.A.
- 121 MONITOR - T.F.S.A.
- 122 CAMERA - T.F.S.A.
- 123 LAUNDRY CHIEF - T.F.S.A.

Equipment Plan

Architect:




Sheet:

A-8.1

U.S. HIGHWAY 90 ALTERNATE
(SOUTH MAIN STREET, WIDTH VARIES)

SITE PLAN

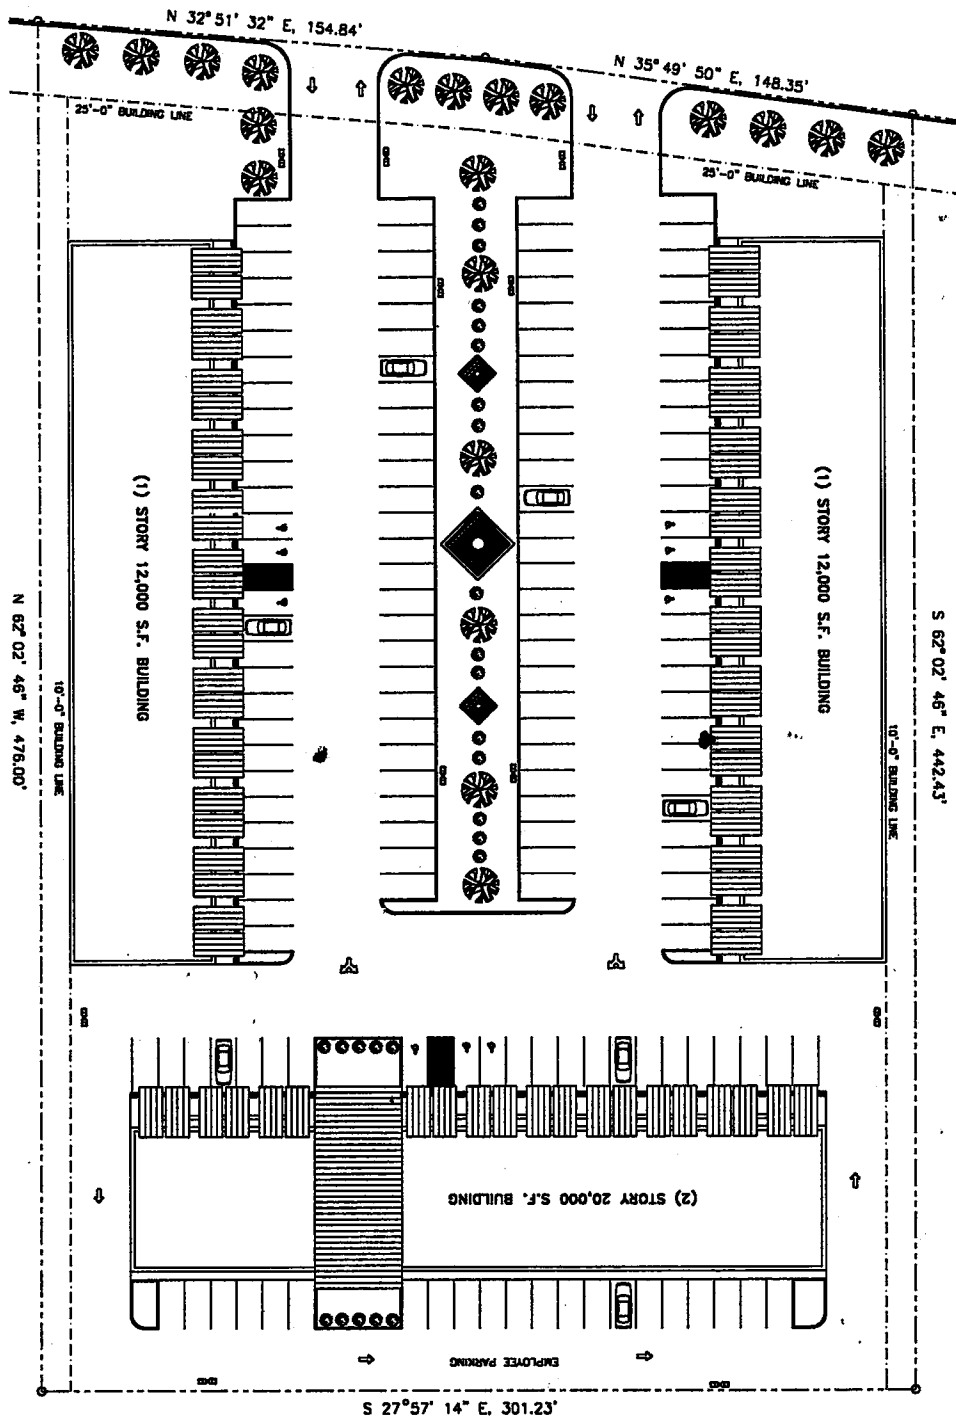TOTAL PROPERTY 3.189 ACRES

K&M
DESIGN
GROUP

3040 POST OAK BLVD, SUITE 1020
HOUSTON, TEXAS 77058
TEL: (713) 625-8100 FAX: (713) 625-8123

THE PLAZA
U.S. HIGHWAY 90 ALT.
SOUTH MAIN

DATE	06-21-02
JOB NUMBER	
DESIGN BY	
DRAWN BY	ALM/BD
SCALE:	1"=20'

SHEET NO.: A-1