



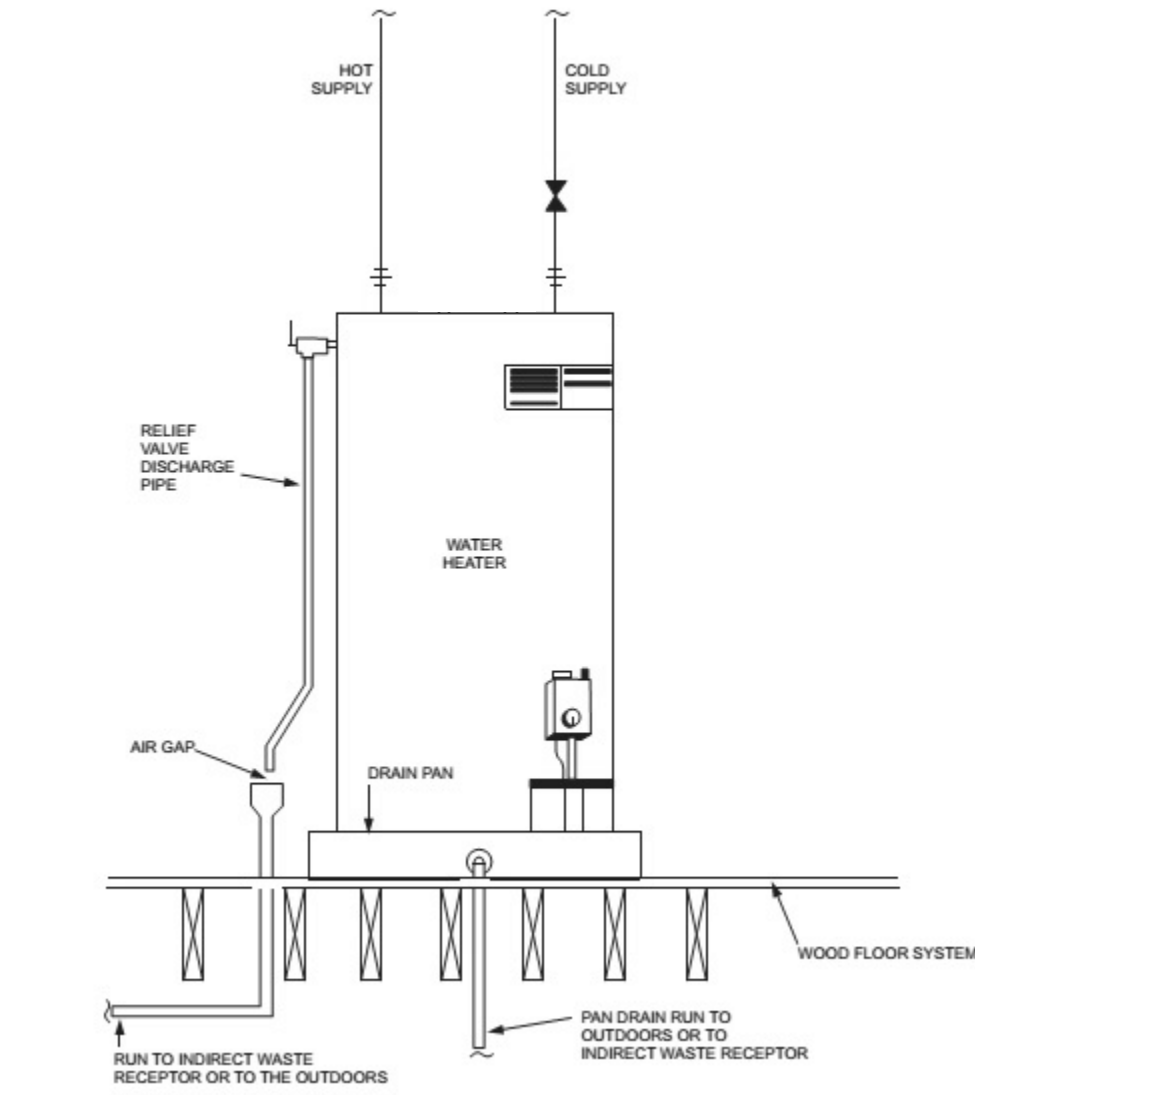


1
A-2 **WATER HEATER DETAIL**
SCALE: 3/16" = 1'-0"

ITEM	
1.	GERBER AV-21-828 WHT AVALANCHE 1.28GPF 1.6GP ADA BOWL WHITE
2.	GERBER AV-28-890 WHT AVALANCHE TANK
3.	Bemis 523SS-000EF OF/LC PLASTIC SEAT W/SELF SUSTAINING CHECK HINGE WHITE
4.	GERBER 12-654 MONTICELLO II WHITE 20 X 18 WALL HUNG LAVATORY
5.	MOEN L64621 CHATEAU 1 HANDLE LAV FAUCET
6.	MUSTEE 63M WHITE 24X24X 10 MOP BASINS T & S B-0665-BSTR SERVICE SINK FAUCET MUSTEE 65.700 HOSE HOLDER MUSTEE 67.2424 STAINLESS STEEL WALL GUARDS
7.	DAYTON D-12522-3 SINGLE BOWL SINK
8.	MOEN 67425 CHATEAU 1 HANDLE KITCHEN FAUCET
9.	STATE ES6-20-SOMS 100328971 19GAL 2500W 120V SIDE CONN 24-3/4 X 18 WATER HEATERS

3
A-2 **Plumbing Fixture Schedule**
SCALE: 1:0.67

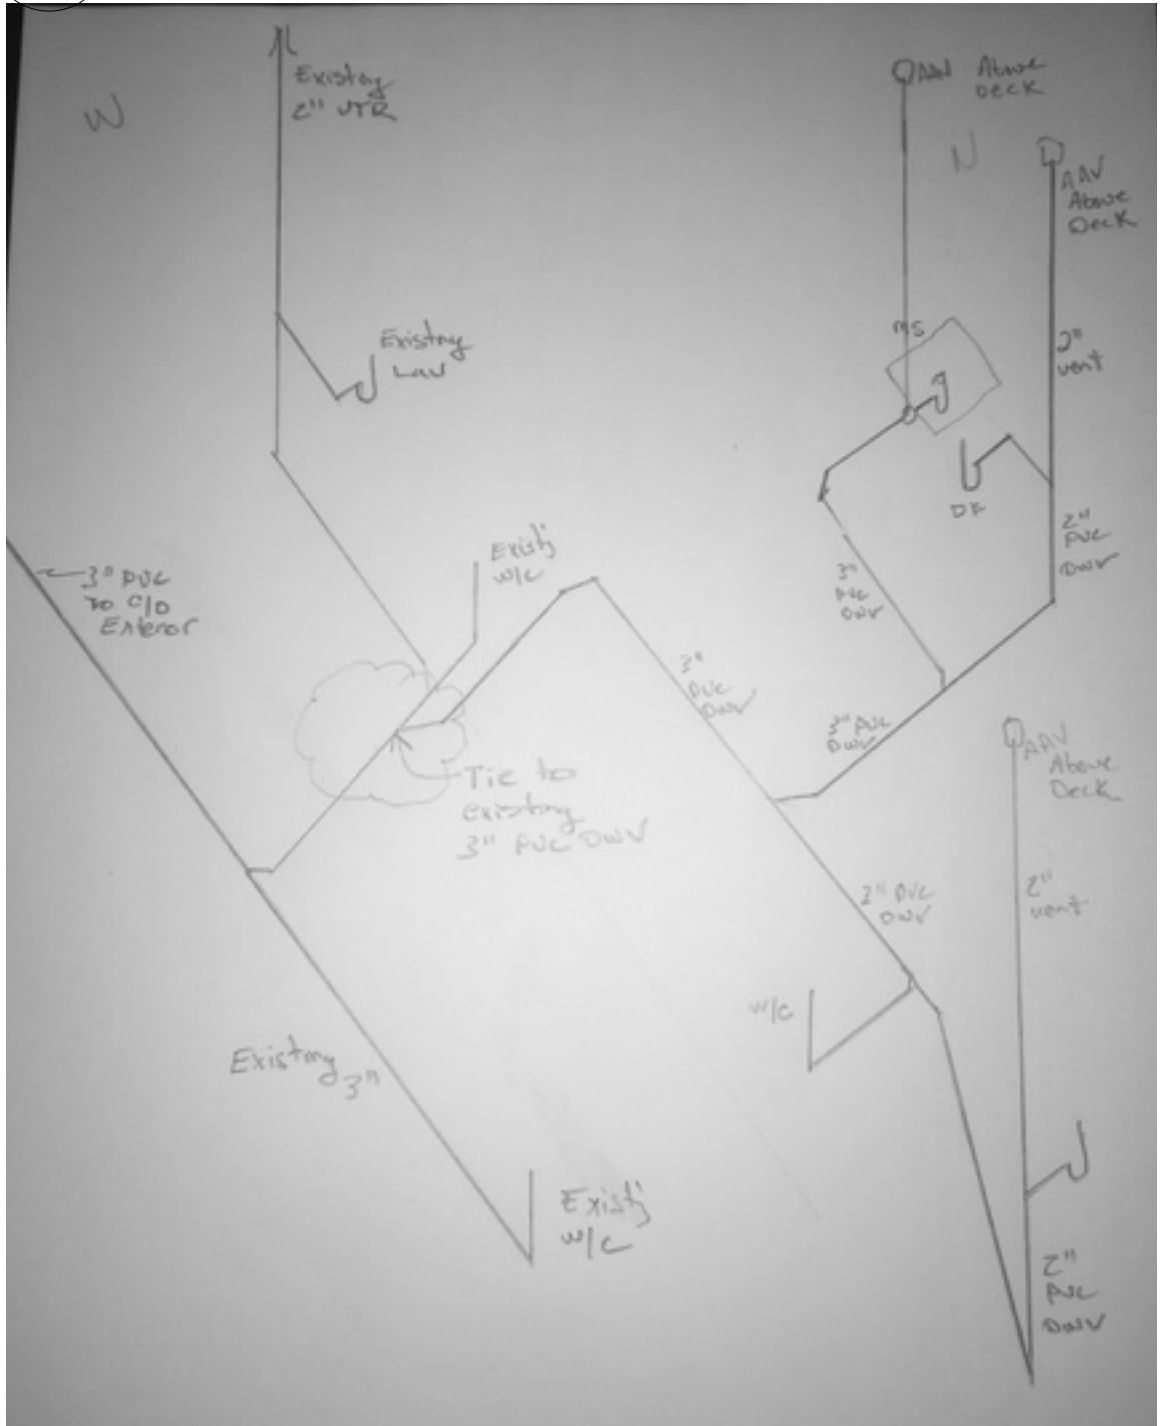


4
A-2 **PLUMBING RISER DIAGRAM**
SCALE: 1/4" = 1'-0"

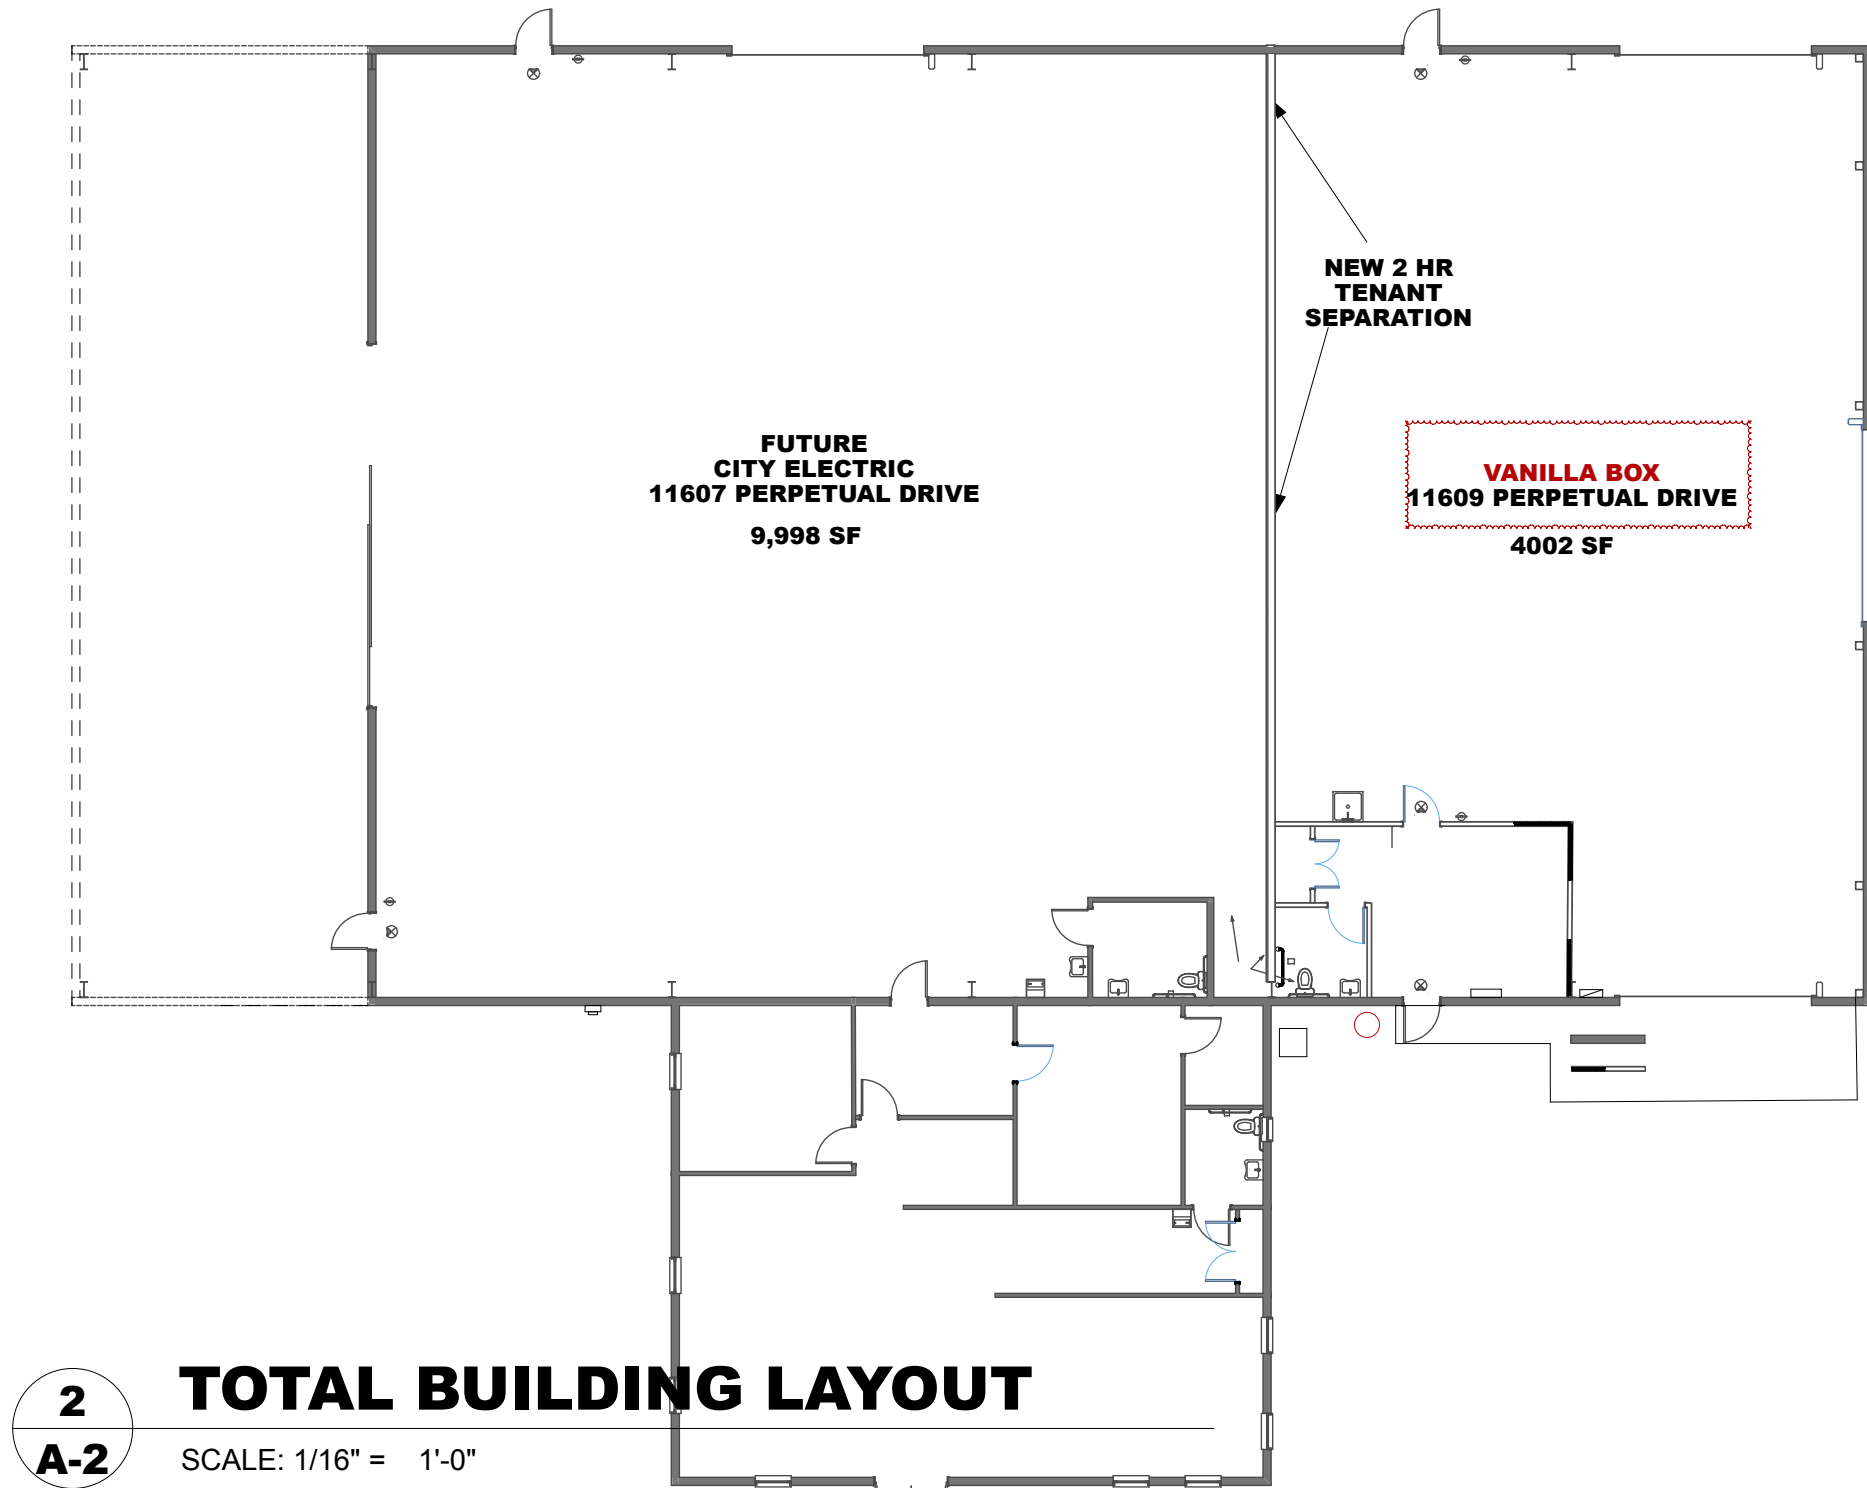

2
A-2 **TOTAL BUILDING LAYOUT**
SCALE: 1/16" = 1'-0"

	COLD WATER 1-1/4"	HOT WATER	WATE LINE 3"	VENT 2"
	1/2"	1/2"	2"	2"
	1/2"	1/2"	2"	2"
	1/2"	1/2"	2"	2"
	1/2"		2"	2"

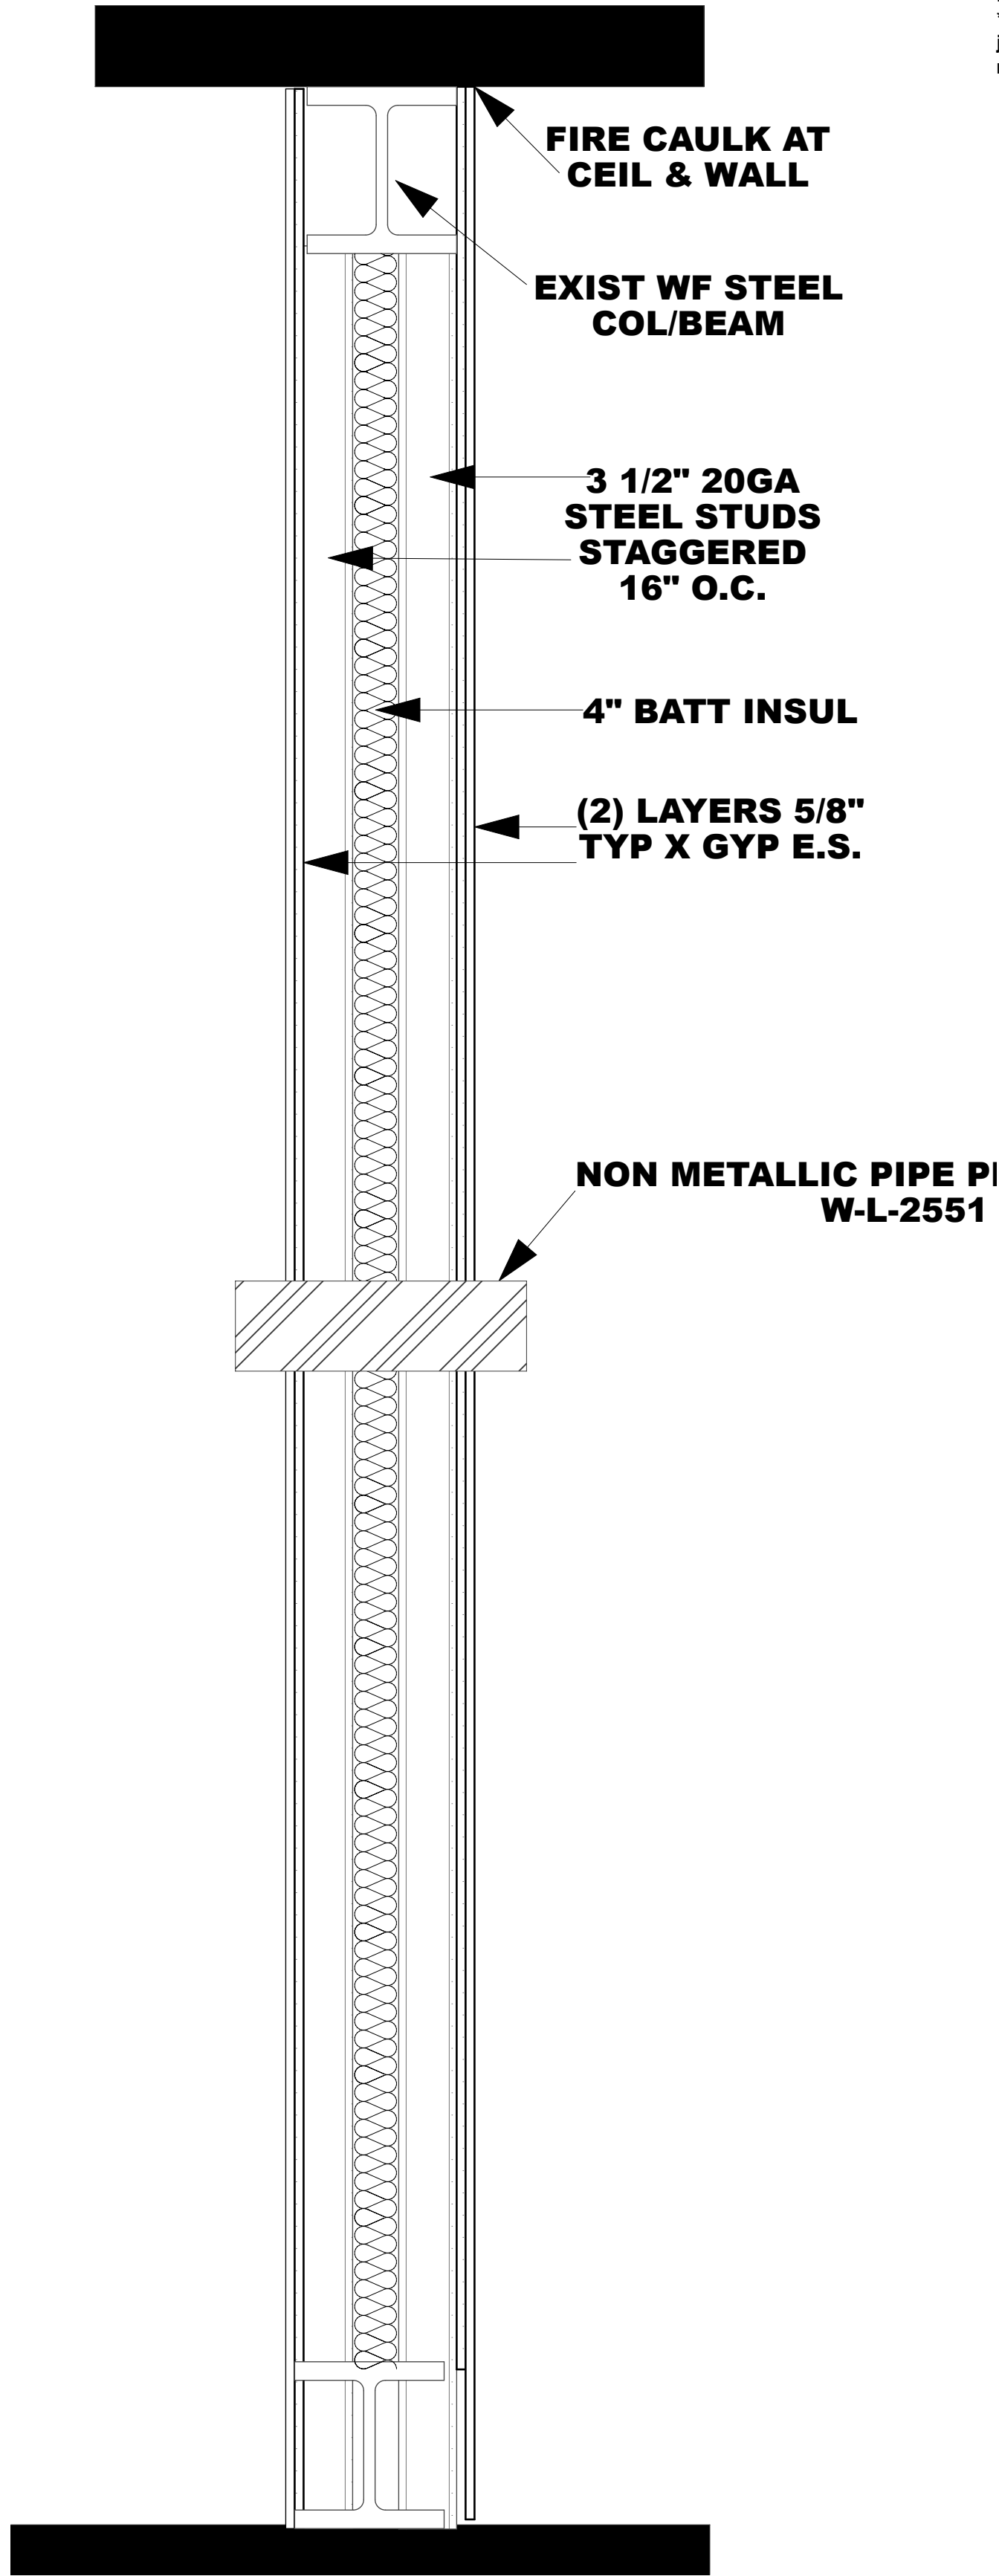

5
A-2 **2 HR WALL SECTION**
SCALE: 1" = 1'-0"

Design No. V488

October 29, 2024
Nonbearing Wall Rating — 1 or 2 Hr. (See Items 5 and 5A)
* Indicates such products shall bear the UL or cUL Certification Mark for jurisdictions employing the UL or cUL Certification (such as Canada), respectively.

PARCH@GATE.NET

PATRICIA M. STOUGH, AIA (727) 733-3769

Patricia M. Stough, Inc.

Architect, Inc.

1634 SAN ROY DRIVE, DUNEDIN, FL 34698

AR 0010684

COPYRIGHT © 2025
BY PATRICIA M. STOUGH

1	09/08/2025	PERMIT SUBMITTAL							
2	09/26/2025	RESUBMIT W/ VANILLA BOX ID							

VACANT VANILLA BOX

11607 PERPETUAL DRIVE
ODESSA, FL 33556

DETAILS

DATE: 07/14/2025
PROJECT ID: 29-26-17-0040-00000-0070
DRAWN BY: MLB

25-12

A-2